


SCALE (METRES)

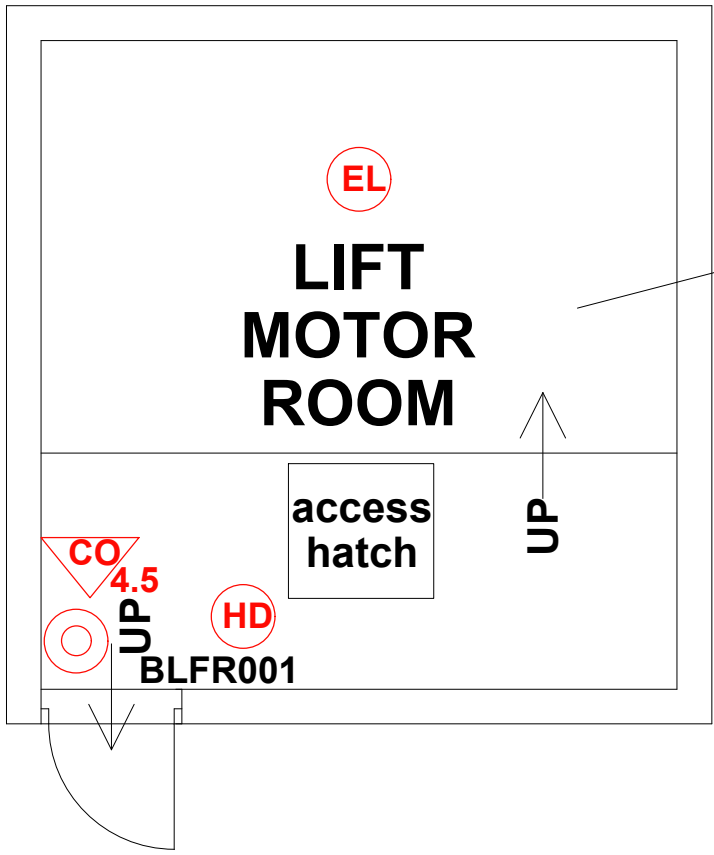

ROOM NOT ACCESSED.  
ASSUMED TO BE SAME  
AS BROWNLEY COURT

FIRE PRECAUTIONS LEGEND

- ⊙ Break glass type fire alarm call point
- HD Heat sensitive detectors
- SD Smoke sensitive detectors
- EL Emergency light point.
- FS Firemans Switch
- DKA Emergency Drop Key Access
- FAP Fire alarm indicator / repeat panel
- GD1 Door/Access fitted with Gerda D1 Key lock
- FB1 Door/Access fitted with FB1 Key lock
- FB2 Door/Access fitted with FB2 Key lock
- FB4 Door/Access fitted with FB4 Key lock
- FB11P Door/Access fitted with FB11 Padlock
- FB14P Door/Access fitted with FB14 Padlock
- DRO Dry Riser Outlet
- DEL Digital electronic lock door entry/exit system
- PIB Premises Information Box
- POV Permanently Open Vent
- AOV Automatic Opening Vent
- OV Openable Vent
- Fire alarm sounder ('X' indicates integral flashing - Xenon light)
- CCTV CCTV Security Camera
- FB Fire Brigade Key Access
- EXTINGUISH
- BLNRT 1.1m x 1.1m fire blanket - base of container to be 1500mm above floor level
- AF 6 litres AFFF aqueous foam extinguisher to BS:6575
- W 9 litre wet chemical type extinguisher
- DP 4.5 4.5 litre dry powder type extinguisher
- CO 2 2 kg carbon dioxide type extinguisher
- CO 4.5 4.5 kg carbon dioxide type extinguisher
- W 9 9 kg water type extinguisher
- W 6 6 litre water type extinguisher
- FIRE EXIT SIGNAGE
- E 'E' Signs to be externally illuminated by adjacent emergency light point
- FE 'FE' denotes as previous but illuminated as part of sign
- RM 'RM' denotes non illuminated sign
- FIRE DOOR SIGNS AND FIRE ACTION NOTICES
- FAN Fire Action Notice
- EFFP Emergency Floor Plan
- KS "FIRE DOOR KEEP SHUT" sign
- KL "FIRE DOOR KEEP LOCKED" sign
- KC "AUTOMATIC FIRE DOOR KEEP CLEAR" or "FIRE EXIT KEEP CLEAR" sign
- LAN "CAUTION, IN THE EVENT OF FIRE DO NOT USE THIS LIFT"
- DB DISTRIBUTION BOARD

# BROWNLEY COURT ROOF SPACE

REV DATE AMENDMENTS



WEB: WWW.FIRNTEC.COM  
EMAIL: CONTACTUS@FIRNTEC.COM  
ADDRESS: 1ST FLOOR, ENDEAVOUR HOUSE,  
PARKWAY CT, PLYMOUTH PL6 8LR  
TEL: 01752 877 147

PROJECT: BROWNLEY COURT  
ADDRESS: BROWNLEY COURT  
WYTHENSHAW  
MANCHESTER  
M22 8UD  
DWG NO.: BR-C\_220020L13  
DWG TITLE:ROOF  
DWG DATE: NOVEMBER 2022  
DWG SIZE: SCALE 1:50 @ A1  
DRAWN: NR CHECKED: BR