




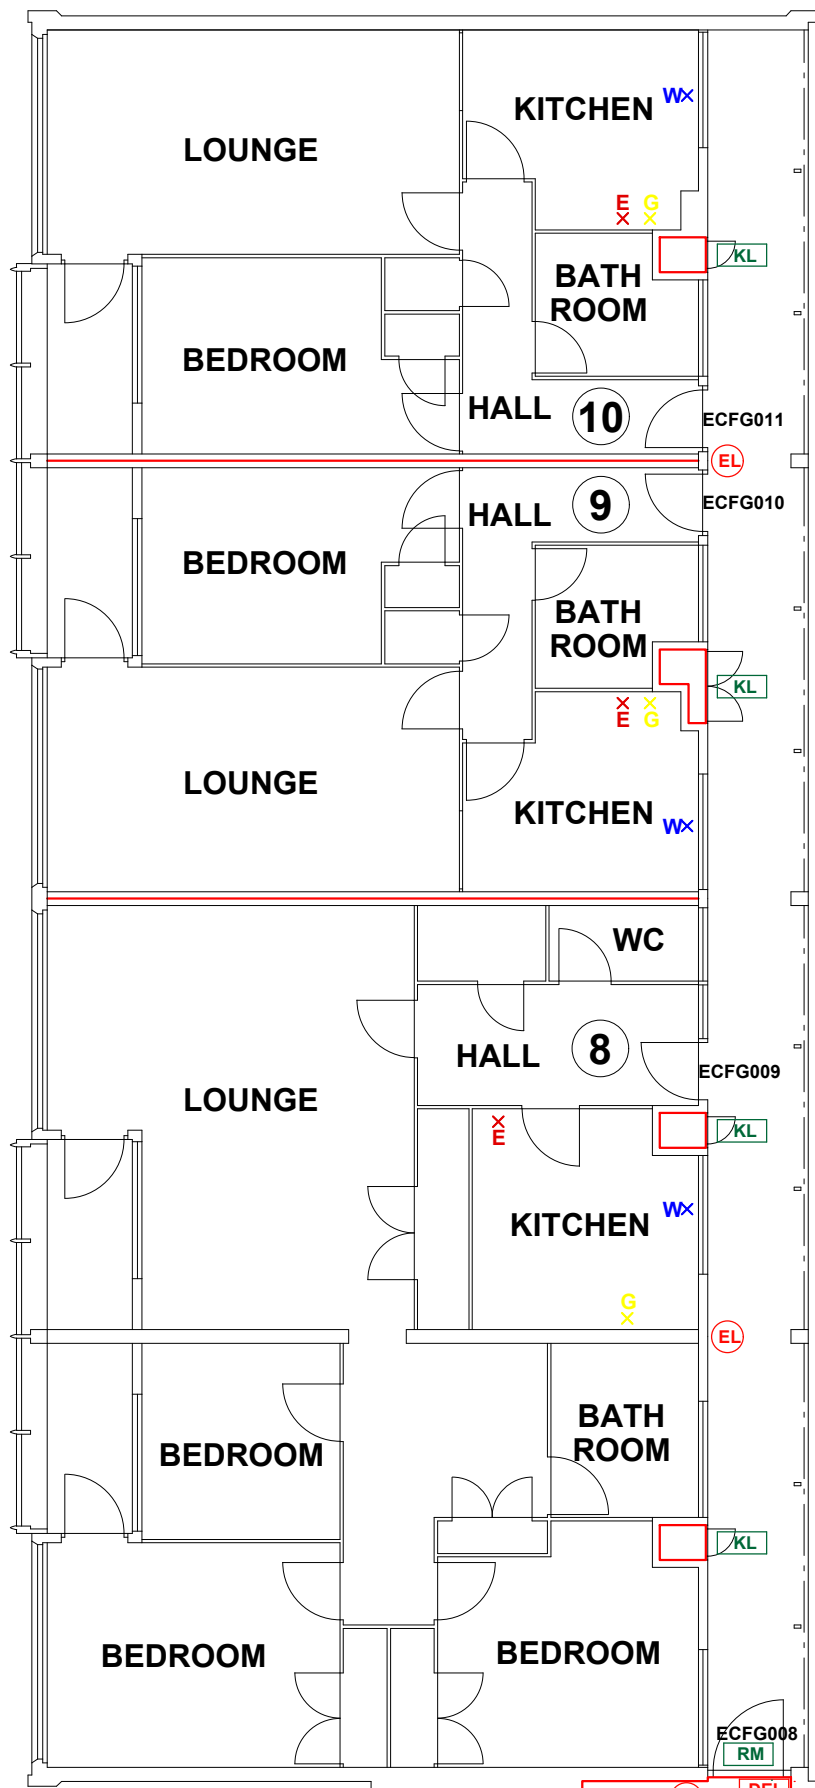

EDWARDS COURT LEVEL 0

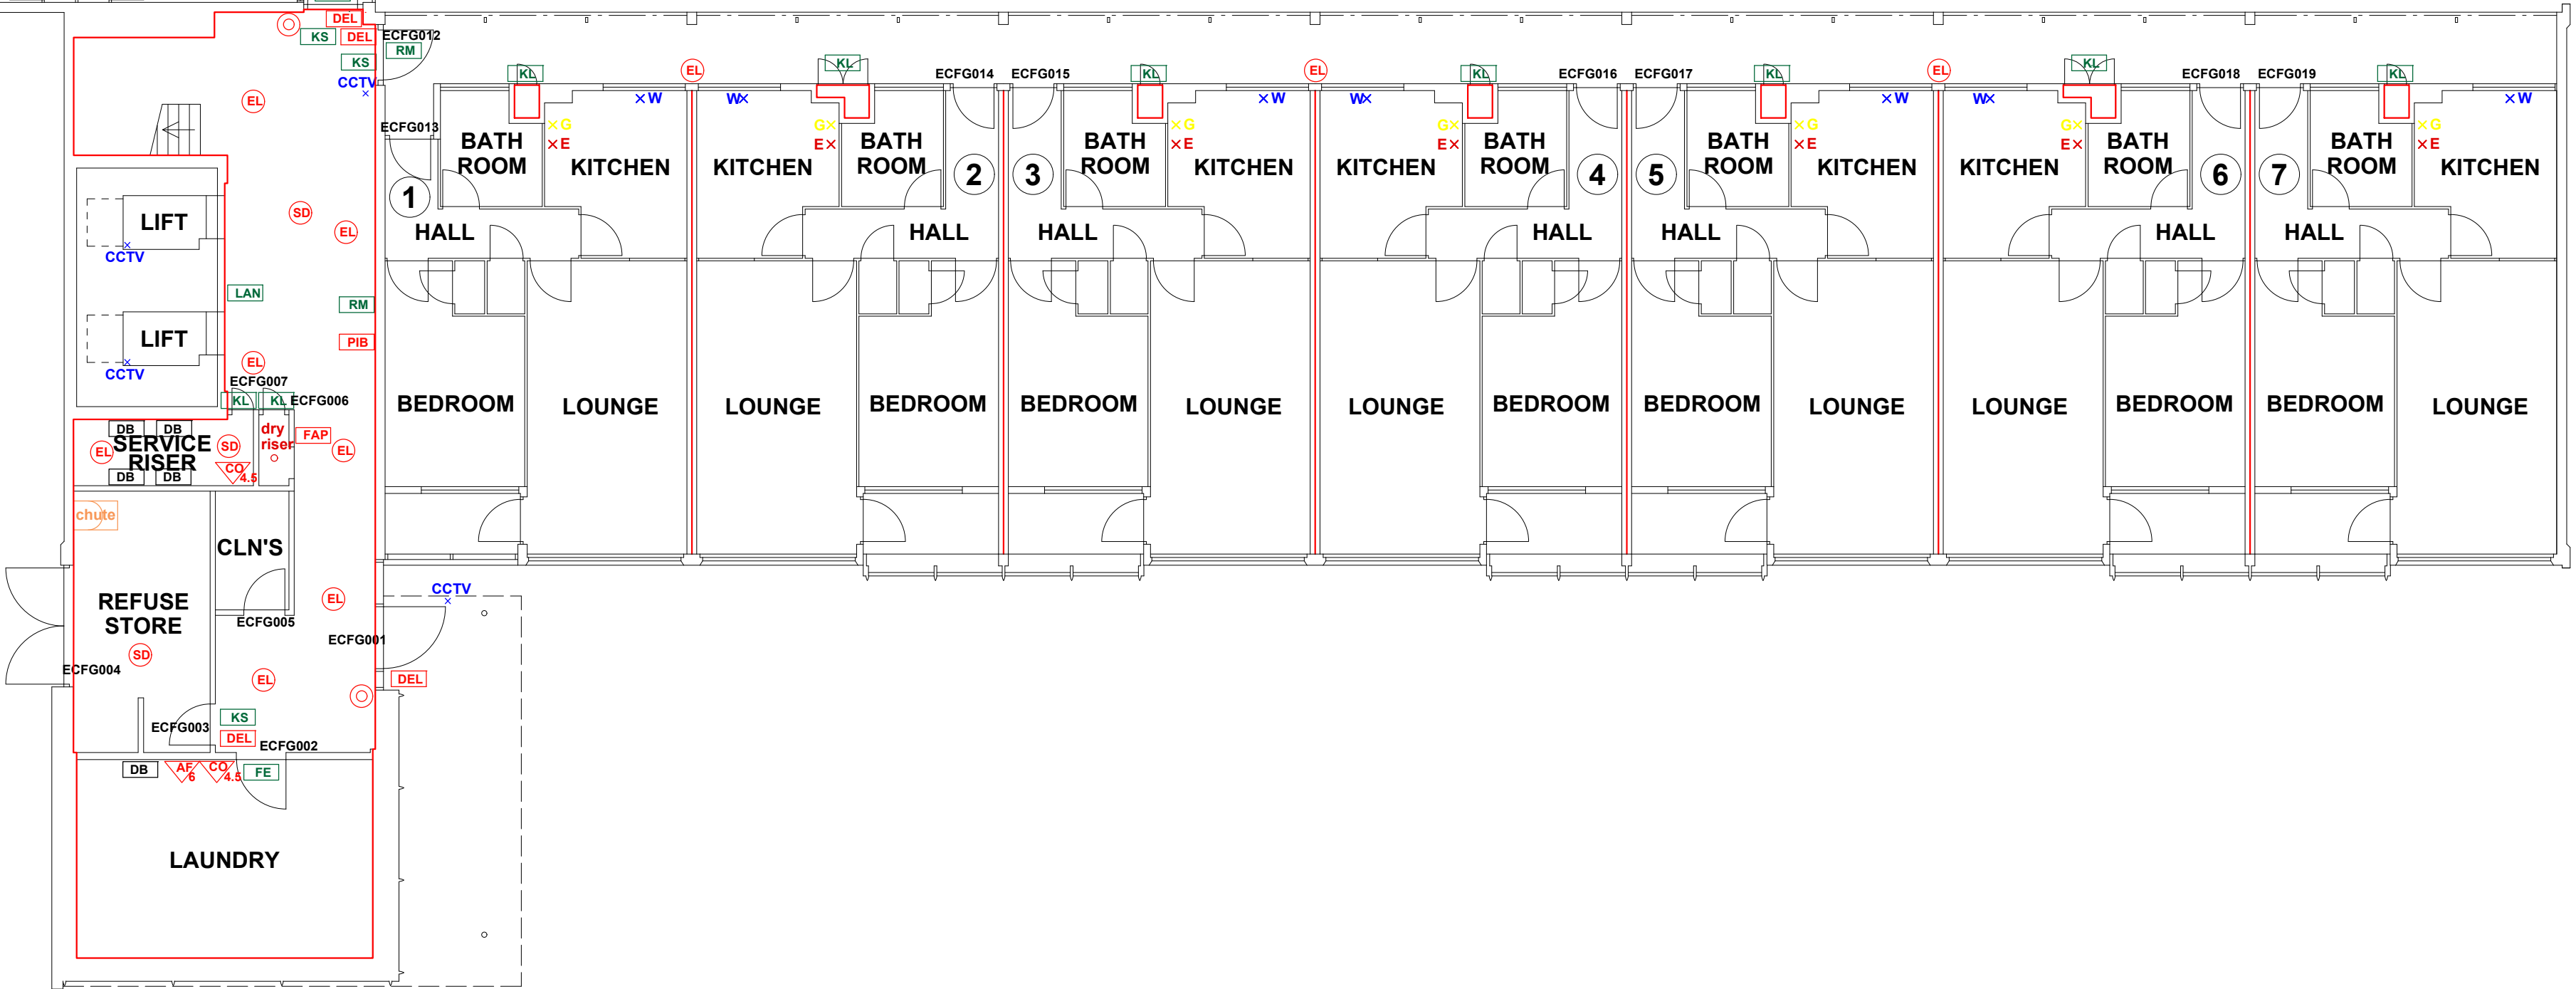

- FIRE PRECAUTIONS LEGEND**
- CB Break glass type fire alarm call point
 - HB Heat sensitive detectors
 - SD Smoke sensitive detectors
 - EL Emergency light point.
 - FS Firemans Switch
 - DKA Emergency Drop Key Access
 - FAP Fire alarm indicator / repeat panel
 - GD1 Door/Access fitted with Gerda D1 Key lock
 - FB1 Door/Access fitted with FB1 Key lock
 - FB2 Door/Access fitted with FB2 Key lock
 - FB4 Door/Access fitted with FB4 Key lock
 - FB11P Door/Access fitted with FB11 Padlock
 - FB14P Door/Access fitted with FB14 Padlock
 - DRO Dry Riser Outlet
 - DEL Digital electronic lock door entry/exit system
 - PIB Premises Information Box
 - POV Permanently Open Vent
 - AOV Automatic Opening Vent
 - OV Openable Vent
 - Fire alarm sounder ('X' indicates integral flashing - Xenon light)
 - CCTV CCTV Security Camera
 - FB Fire Brigade Key Access
- EXTINGUISH**
- BLNRT 1.1m x 1.1m fire blanket - base of container to be 1500mm above floor level
 - AF 6 litres AFFF aqueous foam extinguisher to BS:6575
 - DP 9 litre wet chemical type extinguisher
 - DP 4.5 4.5 litre dry powder type extinguisher
 - CO 2 2 kg carbon dioxide type extinguisher
 - CO 4.5 4.5 kg carbon dioxide type extinguisher
 - W 9 9 kg water type extinguisher
 - W 6 6 litre water type extinguisher
- FIRE EXIT SIGNAGE**
- E 'E' Signs to be externally illuminated by adjacent emergency light point
 - FE 'FE' denotes as previous but illuminated as part of sign
 - RM 'RM' denotes non illuminated sign
- FIRE DOOR SIGNS AND FIRE ACTION NOTICES**
- FAN Fire Action Notice
 - EFP Emergency Floor Plan
 - KS "FIRE DOOR KEEP SHUT" sign
 - KL "FIRE DOOR KEEP LOCKED" sign
 - KC "AUTOMATIC FIRE DOOR KEEP CLEAR" or "FIRE EXIT KEEP CLEAR" sign
 - LAN "CAUTION, IN THE EVENT OF FIRE DO NOT USE THIS LIFT"
 - DB DISTRIBUTION BOARD

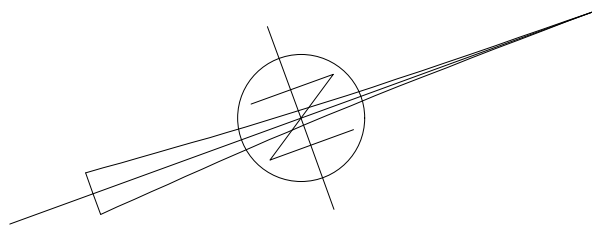


SCALE (METRES)

REV DATE AMENDMENTS



WEB: WWW.FIRNTEC.COM
EMAIL: CONTACTUS@FIRNTEC.COM
ADDRESS: 1ST FLOOR, ENDEAVOUR HOUSE,
PARKWAY CT, PLYMOUTH PL6 8LR
TEL: 01752 877 147

PROJECT: EDWARDS COURT
ADDRESS: WYTHENSHAW
MANCHESTER
M22 3SF
DWG NO.: EC_220020L01
DWG TITLE: LEVEL 0
DWG DATE: NOVEMBER 2022
DWG SIZE: SCALE 1:100 @ A1
DRAWN: NR CHECKED: BR

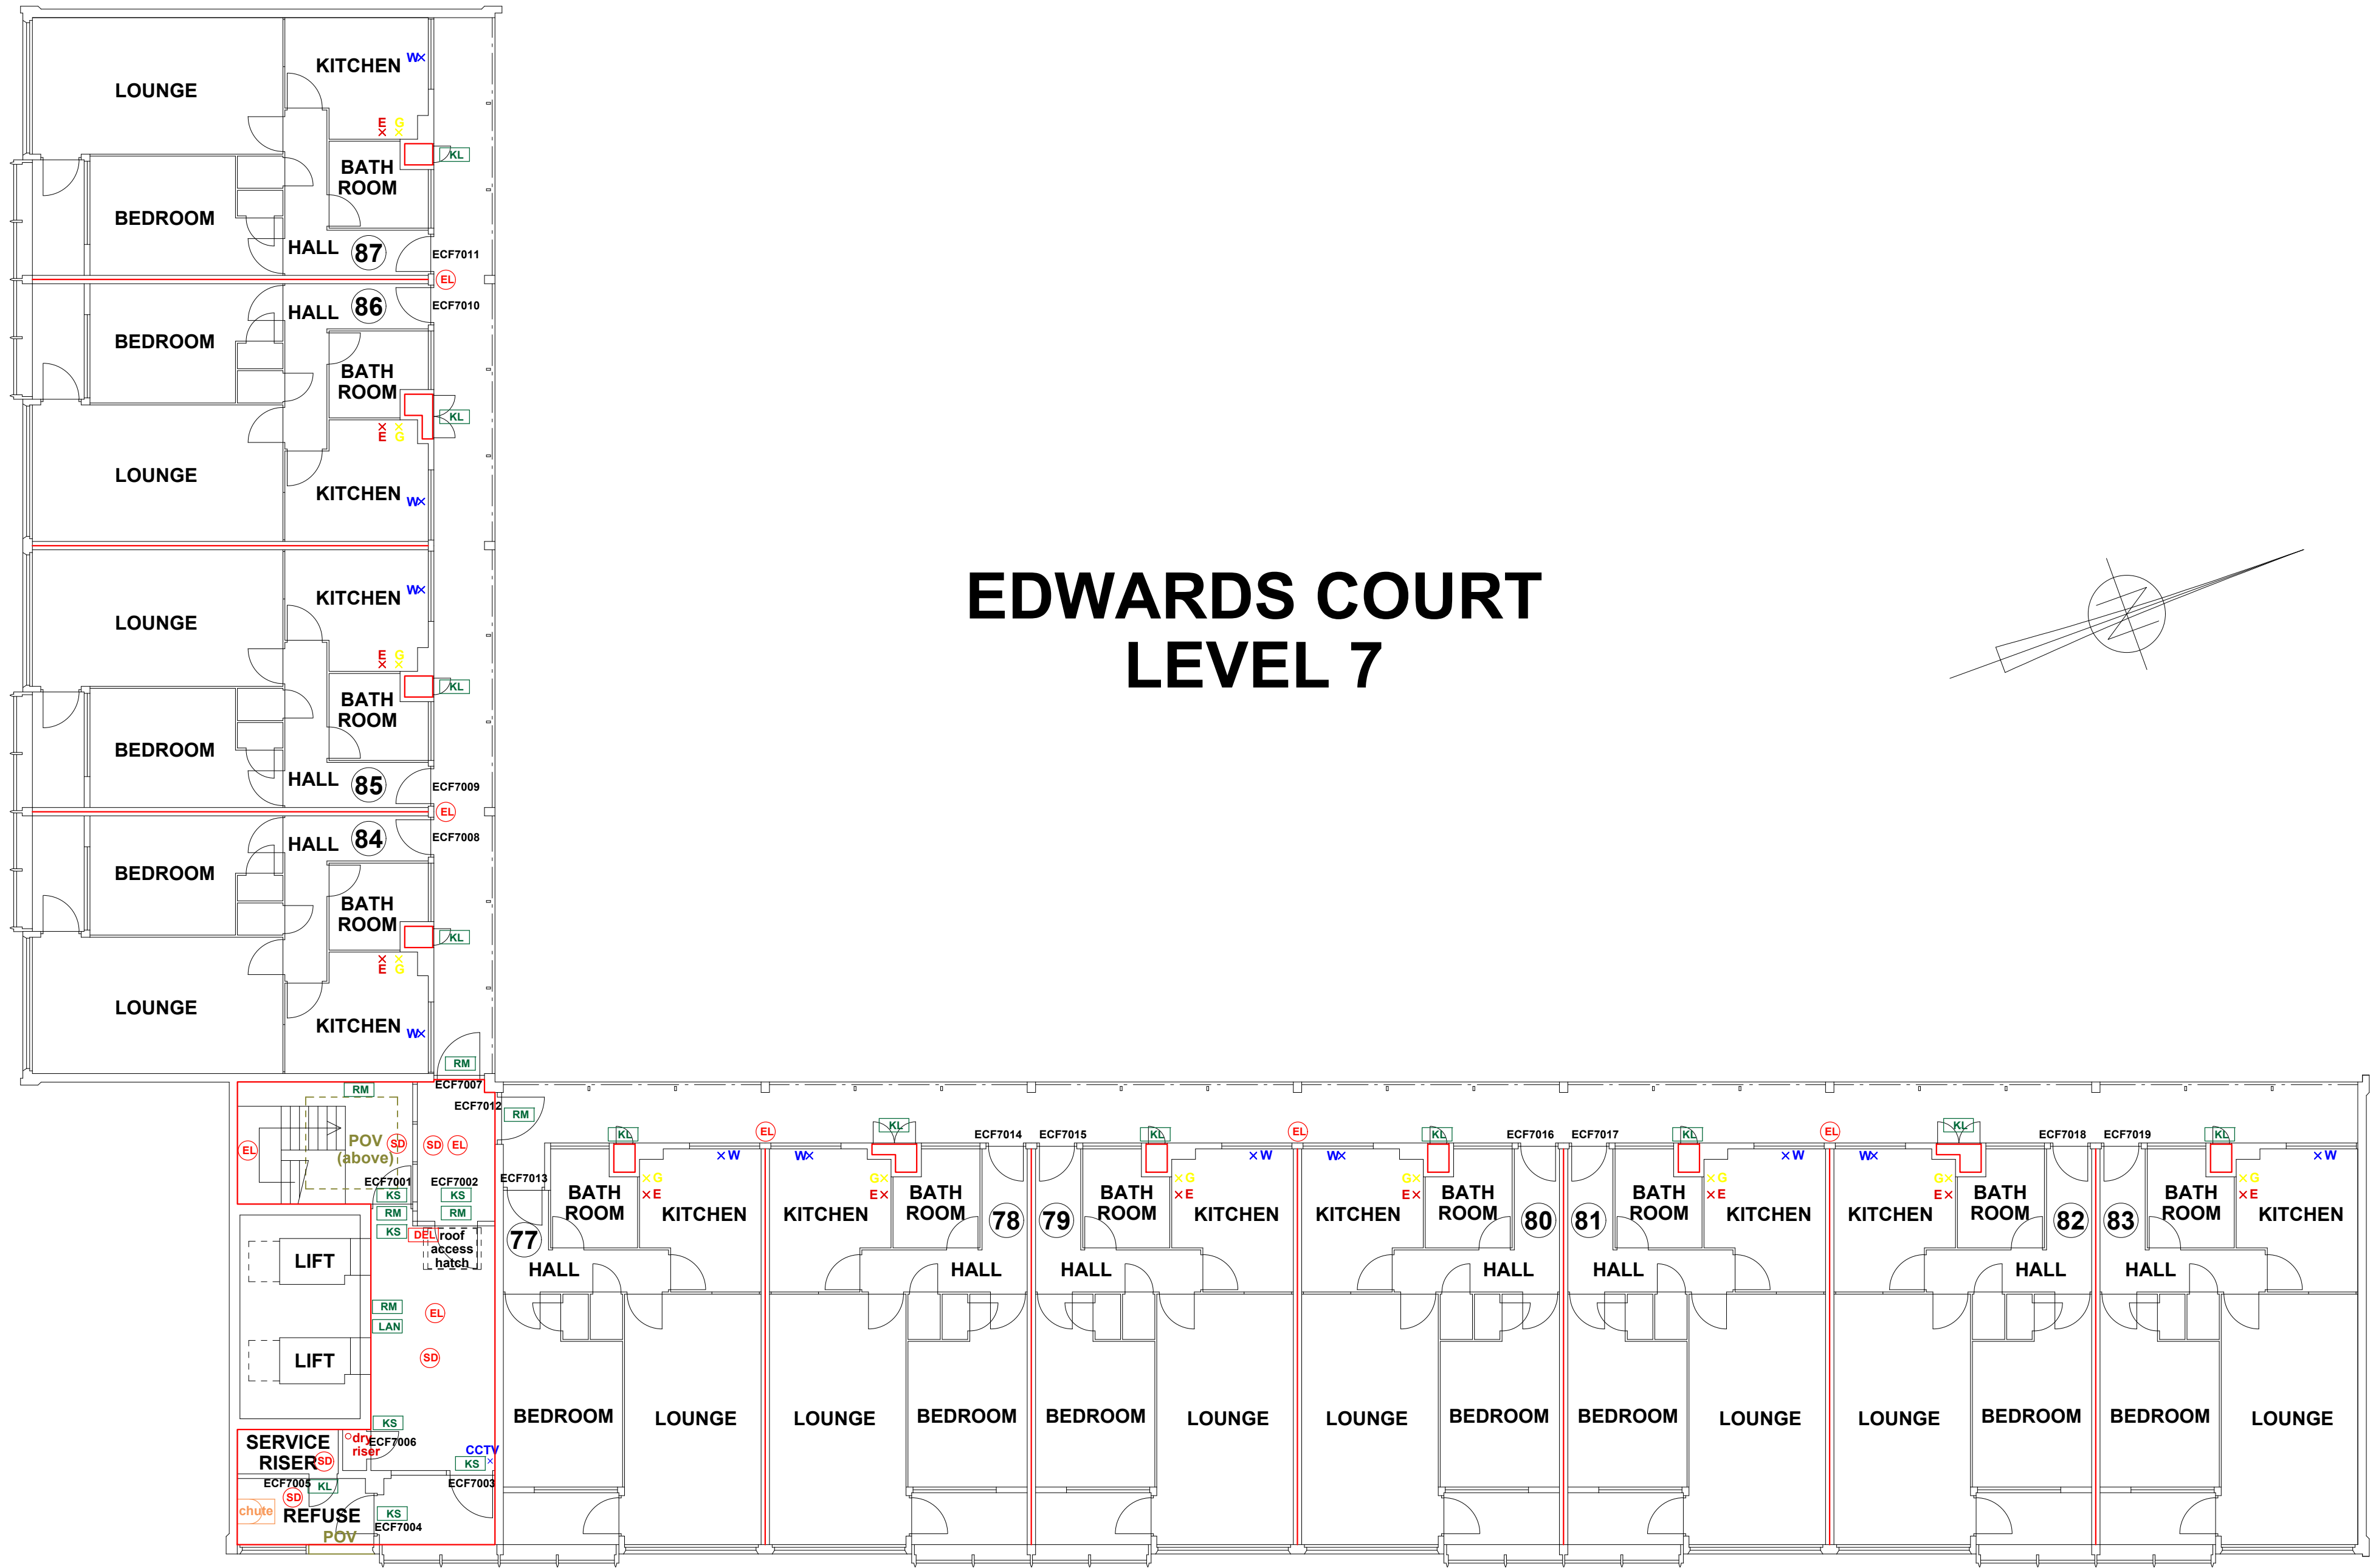

EDWARDS COURT LEVEL 7

FIRE PRECAUTIONS LEGEND

- ⊙ Break glass type fire alarm call point
- ⊙ HB Heat sensitive detectors
- ⊙ SD Smoke sensitive detectors
- ⊙ EL Emergency light point.
- ⊙ FS Firemans Switch
- ⊙ DKA Emergency Drop Key Access
- ⊙ FAP Fire alarm indicator / repeat panel
- ⊙ GD1 Door/Access fitted with Gerda D1 Key lock
- ⊙ FB1 Door/Access fitted with FB1 Key lock
- ⊙ FB2 Door/Access fitted with FB2 Key lock
- ⊙ FB4 Door/Access fitted with FB4 Key lock
- ⊙ FB11P Door/Access fitted with FB11 Padlock
- ⊙ FB14P Door/Access fitted with FB14 Padlock
- ⊙ DRO Dry Riser Outlet
- ⊙ DEL Digital electronic lock door entry/exit system
- ⊙ PIB Premises Information Box
- ⊙ POV Permanently Open Vent
- ⊙ AOV Automatic Opening Vent
- ⊙ OV Openable Vent
- ⊙ Fire alarm sounder ('X' indicates integral flashing - Xenon light)
- ⊙ CCTV CCTV Security Camera
- ⊙ FB Fire Brigade Key Access
- EXTINGUISH
 - ⊙ BELNRT 1.1m x 1.1m fire blanket - base of container to be 1500mm above floor level
 - ⊙ AFFF 6 litres AFFF aqueous foam extinguisher to BS:6575
 - ⊙ C 9 litre wet chemical type extinguisher
 - ⊙ DP 4.5 4.5 litre dry powder type extinguisher
 - ⊙ C 2 kg carbon dioxide type extinguisher
 - ⊙ C 4.5 4.5 kg carbon dioxide type extinguisher
 - ⊙ W 9 9 kg water type extinguisher
 - ⊙ W 6 6 litre water type extinguisher
- FIRE EXIT SIGNAGE
 - ⊙ E 'E' Signs to be externally illuminated by adjacent emergency light point
 - ⊙ FE 'FE' denotes as previous but illuminated as part of sign
 - ⊙ RM 'RM' denotes non illuminated sign
- FIRE DOOR SIGNS AND FIRE ACTION NOTICES
 - ⊙ FAN Fire Action Notice
 - ⊙ EFP Emergency Floor Plan
 - ⊙ KS "FIRE DOOR KEEP SHUT" sign
 - ⊙ KL "FIRE DOOR KEEP LOCKED" sign
 - ⊙ KC "AUTOMATIC FIRE DOOR KEEP CLEAR" or "FIRE EXIT KEEP CLEAR" sign
 - ⊙ LAN "CAUTION, IN THE EVENT OF FIRE DO NOT USE THIS LIFT"
 - ⊙ DB DISTRIBUTION BOARD


0 5 10
SCALE (METRES)

REV DATE AMENDMENTS



WEB: WWW.FIRNTEC.COM
EMAIL: CONTACTUS@FIRNTEC.COM
ADDRESS: 1ST FLOOR, ENDEAVOUR HOUSE,
PARKWAY CT, PLYMOUTH PL6 8LR
TEL: 01752 877 147

PROJECT: EDWARDS COURT
ADDRESS: EDWARDS COURT
WYTHENSHAW
MANCHESTER
M22 3SE
DWG NO.: EC_220020L08
DWG TITLE: LEVEL 7
DWG DATE: NOVEMBER 2022
DWG SIZE: SCALE 1:100 @ A1
DRAWN: NR CHECKED: BR

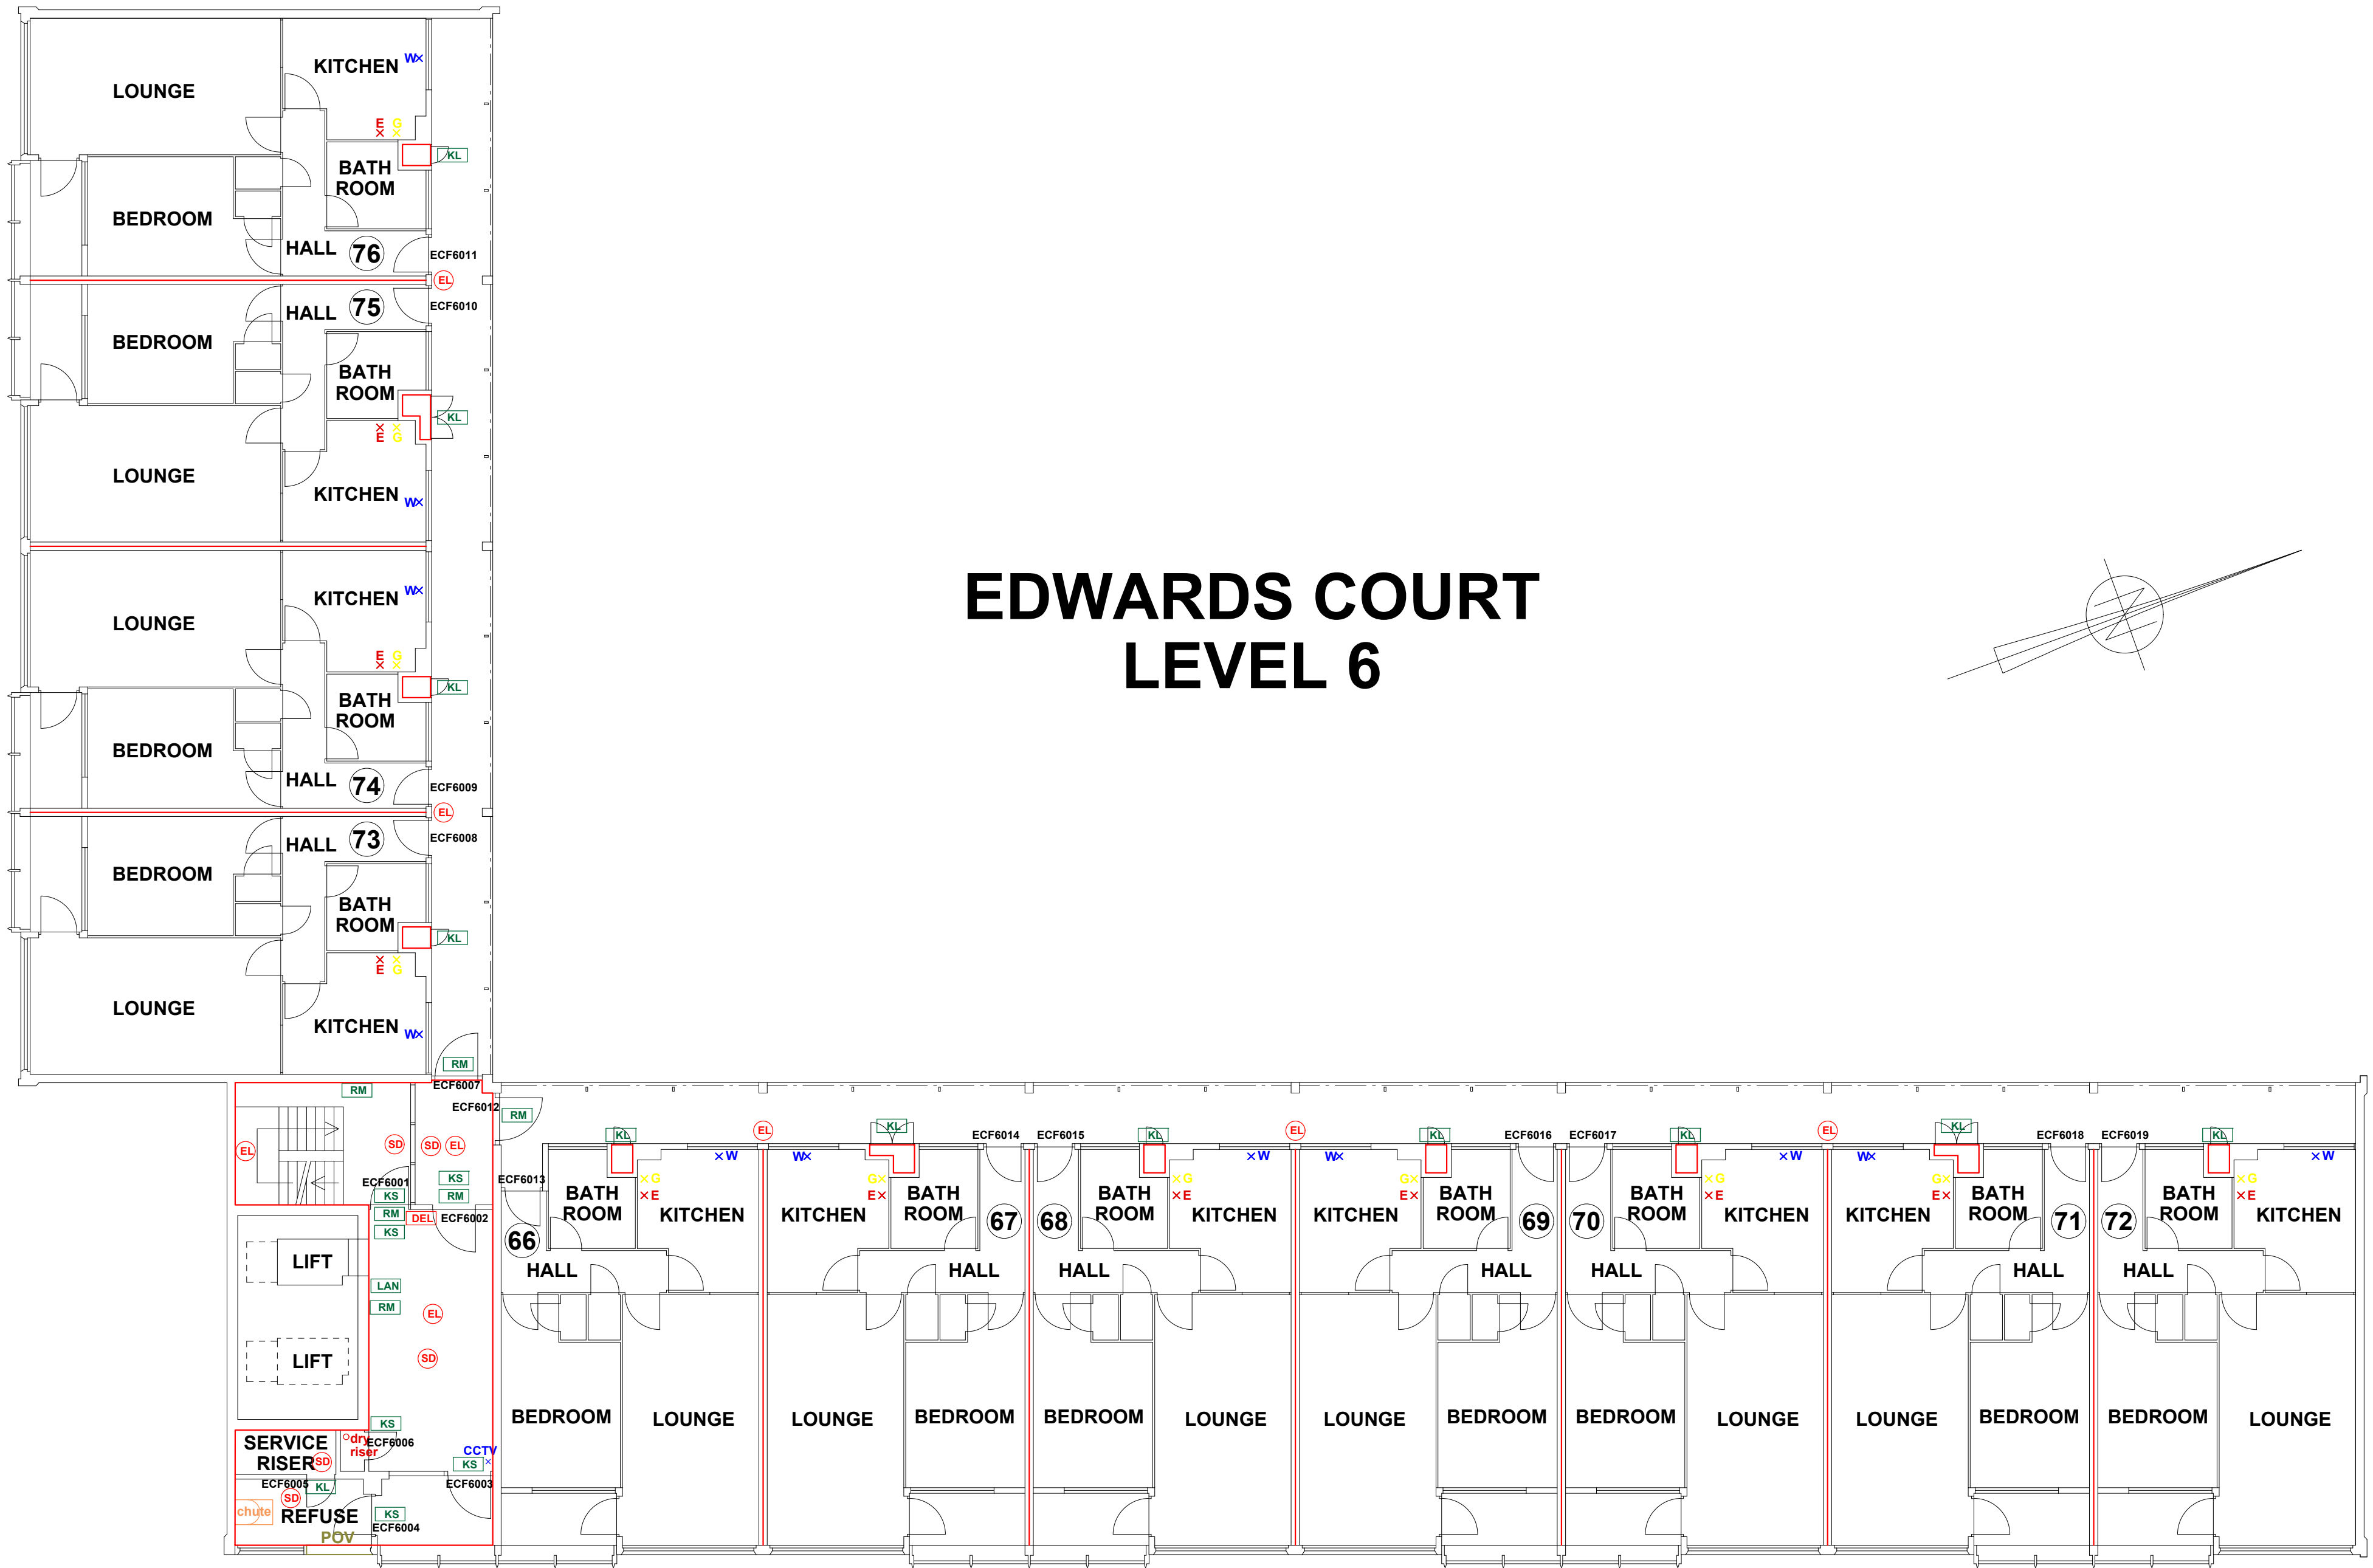

EDWARDS COURT LEVEL 6

FIRE PRECAUTIONS LEGEND

- ⊙ Break glass type fire alarm call point
- HD Heat sensitive detectors
- SD Smoke sensitive detectors
- EL Emergency light point.
- FS Firemans Switch
- DKA Emergency Drop Key Access
- FAP Fire alarm indicator / repeat panel
- GD1 Door/Access fitted with Gerda D1 Key lock
- FB1 Door/Access fitted with FB1 Key lock
- FB2 Door/Access fitted with FB2 Key lock
- FB4 Door/Access fitted with FB4 Key lock
- FB11P Door/Access fitted with FB11 Padlock
- FB14P Door/Access fitted with FB14 Padlock
- DRO Dry Riser Outlet
- DEL Digital electronic lock door entry/exit system
- PIB Premises Information Box
- POV Permanently Open Vent
- AOV Automatic Opening Vent
- OV Openable Vent
- X Fire alarm sounder ('X' indicates integral flashing - Xenon light)

EXTINGUISH

- BLNRT 1.1m x 1.1m fire blanket - base of container to be 1500mm above floor level
- AF 6 litres AFFF aqueous foam extinguisher to BS:6575
- C 9 litre wet chemical type extinguisher
- DP 4.5 4.5 litre dry powder type extinguisher
- CO 2 2 kg carbon dioxide type extinguisher
- CO 4.5 4.5 kg carbon dioxide type extinguisher
- W 9 9 kg water type extinguisher
- W 6 6 litre water type extinguisher

FIRE EXIT SIGNAGE

- E 'E' Signs to be externally illuminated by adjacent emergency light point
- FE 'FE' denotes as previous but illuminated as part of sign
- RM 'RM' denotes non illuminated sign

FIRE DOOR SIGNS AND FIRE ACTION NOTICES

- FAN Fire Action Notice
- EFP Emergency Floor Plan
- KS "FIRE DOOR KEEP SHUT" sign
- KL "FIRE DOOR KEEP LOCKED" sign
- KC "AUTOMATIC FIRE DOOR KEEP CLEAR" or "FIRE EXIT KEEP CLEAR" sign
- LAN "CAUTION, IN THE EVENT OF FIRE DO NOT USE THIS LIFT"
- DB DISTRIBUTION BOARD

0 5 10
SCALE (METRES)

REV DATE AMENDMENTS



WEB: WWW.FIRNTEC.COM
EMAIL: CONTACTUS@FIRNTEC.COM
ADDRESS: 1ST FLOOR, ENDEAVOUR HOUSE,
PARKWAY CT, PLYMOUTH PL6 8LR
TEL: 01752 877 147

PROJECT: EDWARDS COURT

ADDRESS: WYTHENSHAW
MANCHESTER
M22 5SE

DWG NO.: EC_220020L07

DWG TITLE: LEVEL 6


DWG DATE: NOVEMBER 2022

DWG SIZE: SCALE 1:100 @ A1

DRAWN: NR

CHECKED: BR

ISSUE

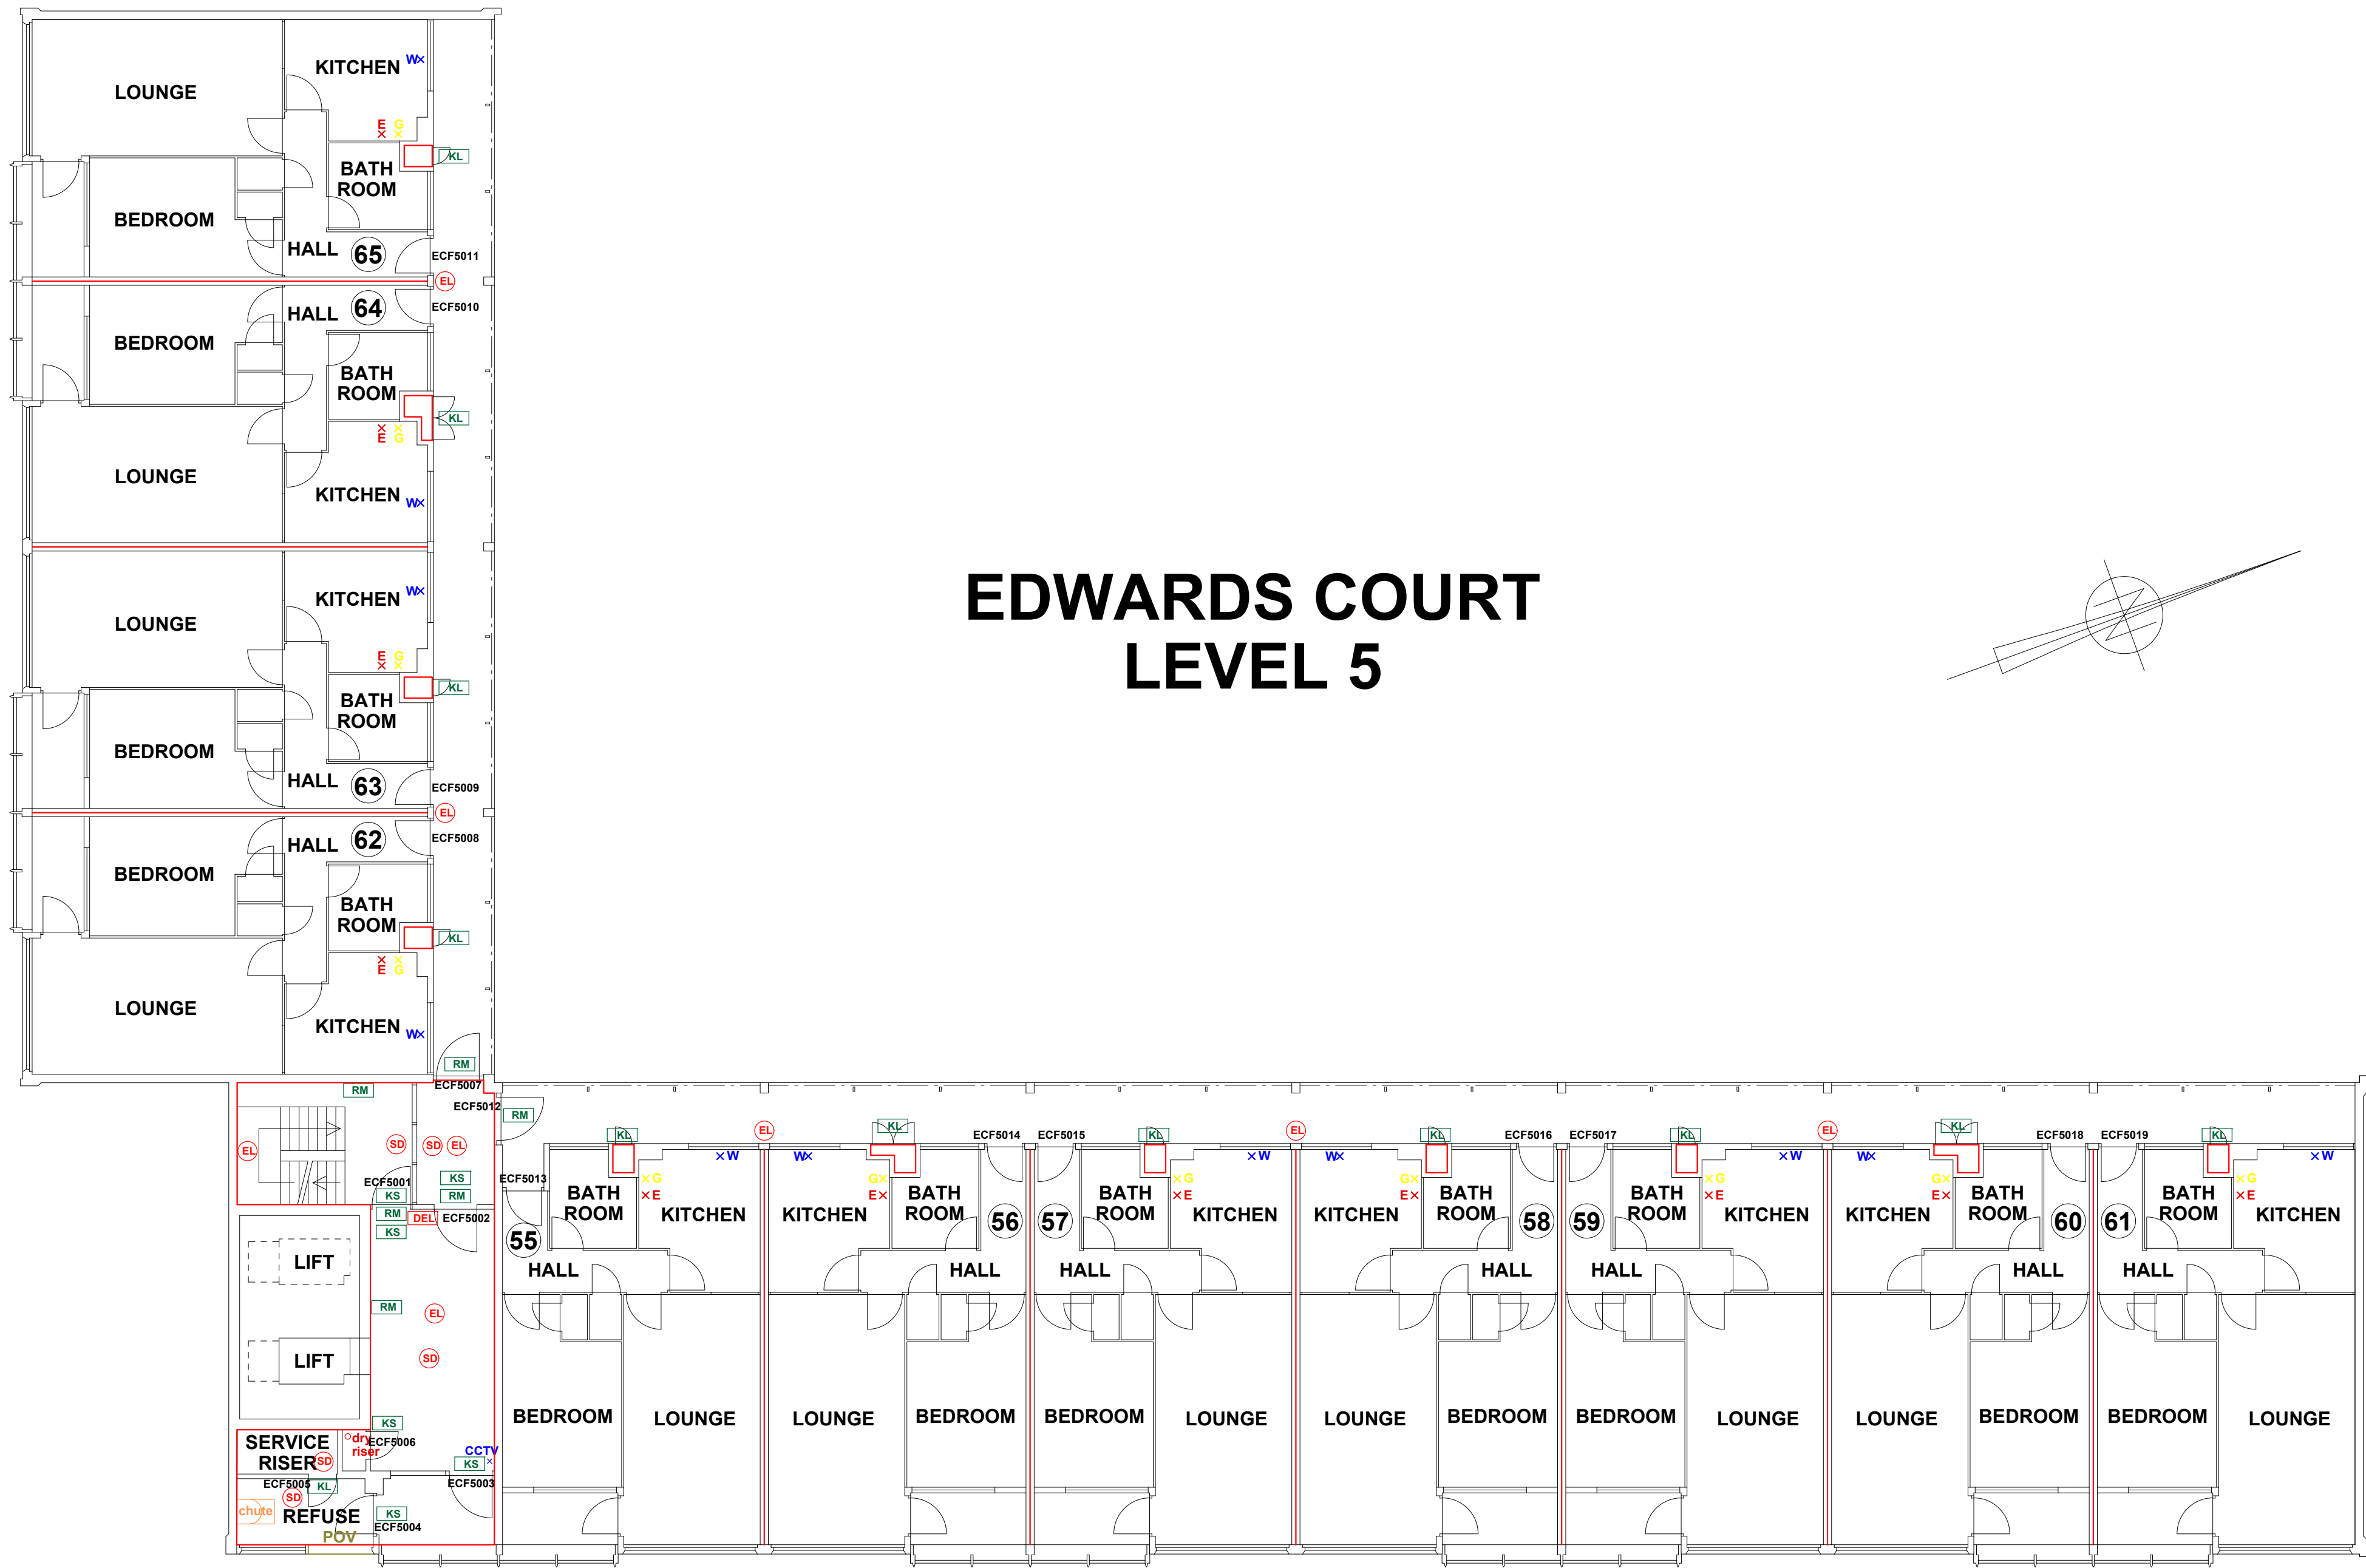

FIRE PRECAUTIONS LEGEND

- ⊙ Break glass type fire alarm call point
- ⊙ HB Heat sensitive detectors
- ⊙ SD Smoke sensitive detectors
- ⊙ EL Emergency light point.
- ⊙ FS Firemans Switch
- ⊙ DKA Emergency Drop Key Access
- ⊙ FAP Fire alarm indicator / repeat panel
- ⊙ GD1 Door/Access fitted with Gerda D1 Key lock
- ⊙ FB1 Door/Access fitted with FB1 Key lock
- ⊙ FB2 Door/Access fitted with FB2 Key lock
- ⊙ FB4 Door/Access fitted with FB4 Key lock
- ⊙ FB11P Door/Access fitted with FB11 Padlock
- ⊙ FB14P Door/Access fitted with FB14 Padlock
- ⊙ DRO Dry Riser Outlet
- ⊙ DEL Digital electronic lock door entry/exit system
- ⊙ PIB Premises Information Box
- ⊙ POV Permanently Open Vent
- ⊙ AOV Automatic Opening Vent
- ⊙ OV Openable Vent
- ⊙ Fire alarm sounder ('X' indicates integral flashing - Xenon light)
- ⊙ CCTV CCTV Security Camera
- ⊙ FB Fire Brigade Key Access
- EXTINGUISH
- ⊙ BLNRT 1.1m x 1.1m fire blanket - base of container to be 1500mm above floor level
- ⊙ A 6 litres AFFF aqueous foam extinguisher to BS:6575
- ⊙ 4 9 litre wet chemical type extinguisher
- ⊙ DP 4.5 4.5 litre dry powder type extinguisher
- ⊙ C 2 2 kg carbon dioxide type extinguisher
- ⊙ C 4.5 4.5 kg carbon dioxide type extinguisher
- ⊙ W 9 9 kg water type extinguisher
- ⊙ W 6 6 litre water type extinguisher
- FIRE EXIT SIGNAGE
- ⊙ E 'E' Signs to be externally illuminated by adjacent emergency light point
- ⊙ FE 'FE' denotes as previous but illuminated as part of sign
- ⊙ RM 'RM' denotes non illuminated sign
- FIRE DOOR SIGNS AND FIRE ACTION NOTICES
- ⊙ FAN Fire Action Notice
- ⊙ EFP Emergency Floor Plan
- ⊙ KS "FIRE DOOR KEEP SHUT" sign
- ⊙ KL "FIRE DOOR KEEP LOCKED" sign
- ⊙ KC "AUTOMATIC FIRE DOOR KEEP CLEAR" or "FIRE EXIT KEEP CLEAR" sign
- ⊙ LAN "CAUTION, IN THE EVENT OF FIRE DO NOT USE THIS LIFT"
- ⊙ DB DISTRIBUTION BOARD


0 5 10
SCALE (METRES)

REV DATE AMENDMENTS



WEB: WWW.FIRNTEC.COM
EMAIL: CONTACTUS@FIRNTEC.COM
ADDRESS: 1ST FLOOR, ENDEAVOUR HOUSE,
PARKWAY CT, PLYMOUTH PL6 8LR
TEL: 01752 877 147

PROJECT: EDWARDS COURT
ADDRESS: EDWARDS COURT
WYTHENSHAW
MANCHESTER
M22 3SE
DWG NO.: EC_220020L06
DWG TITLE: LEVEL 5
DWG DATE: NOVEMBER 2022
DWG SIZE: SCALE 1:100 @ A1
DRAWN: NR CHECKED: BR

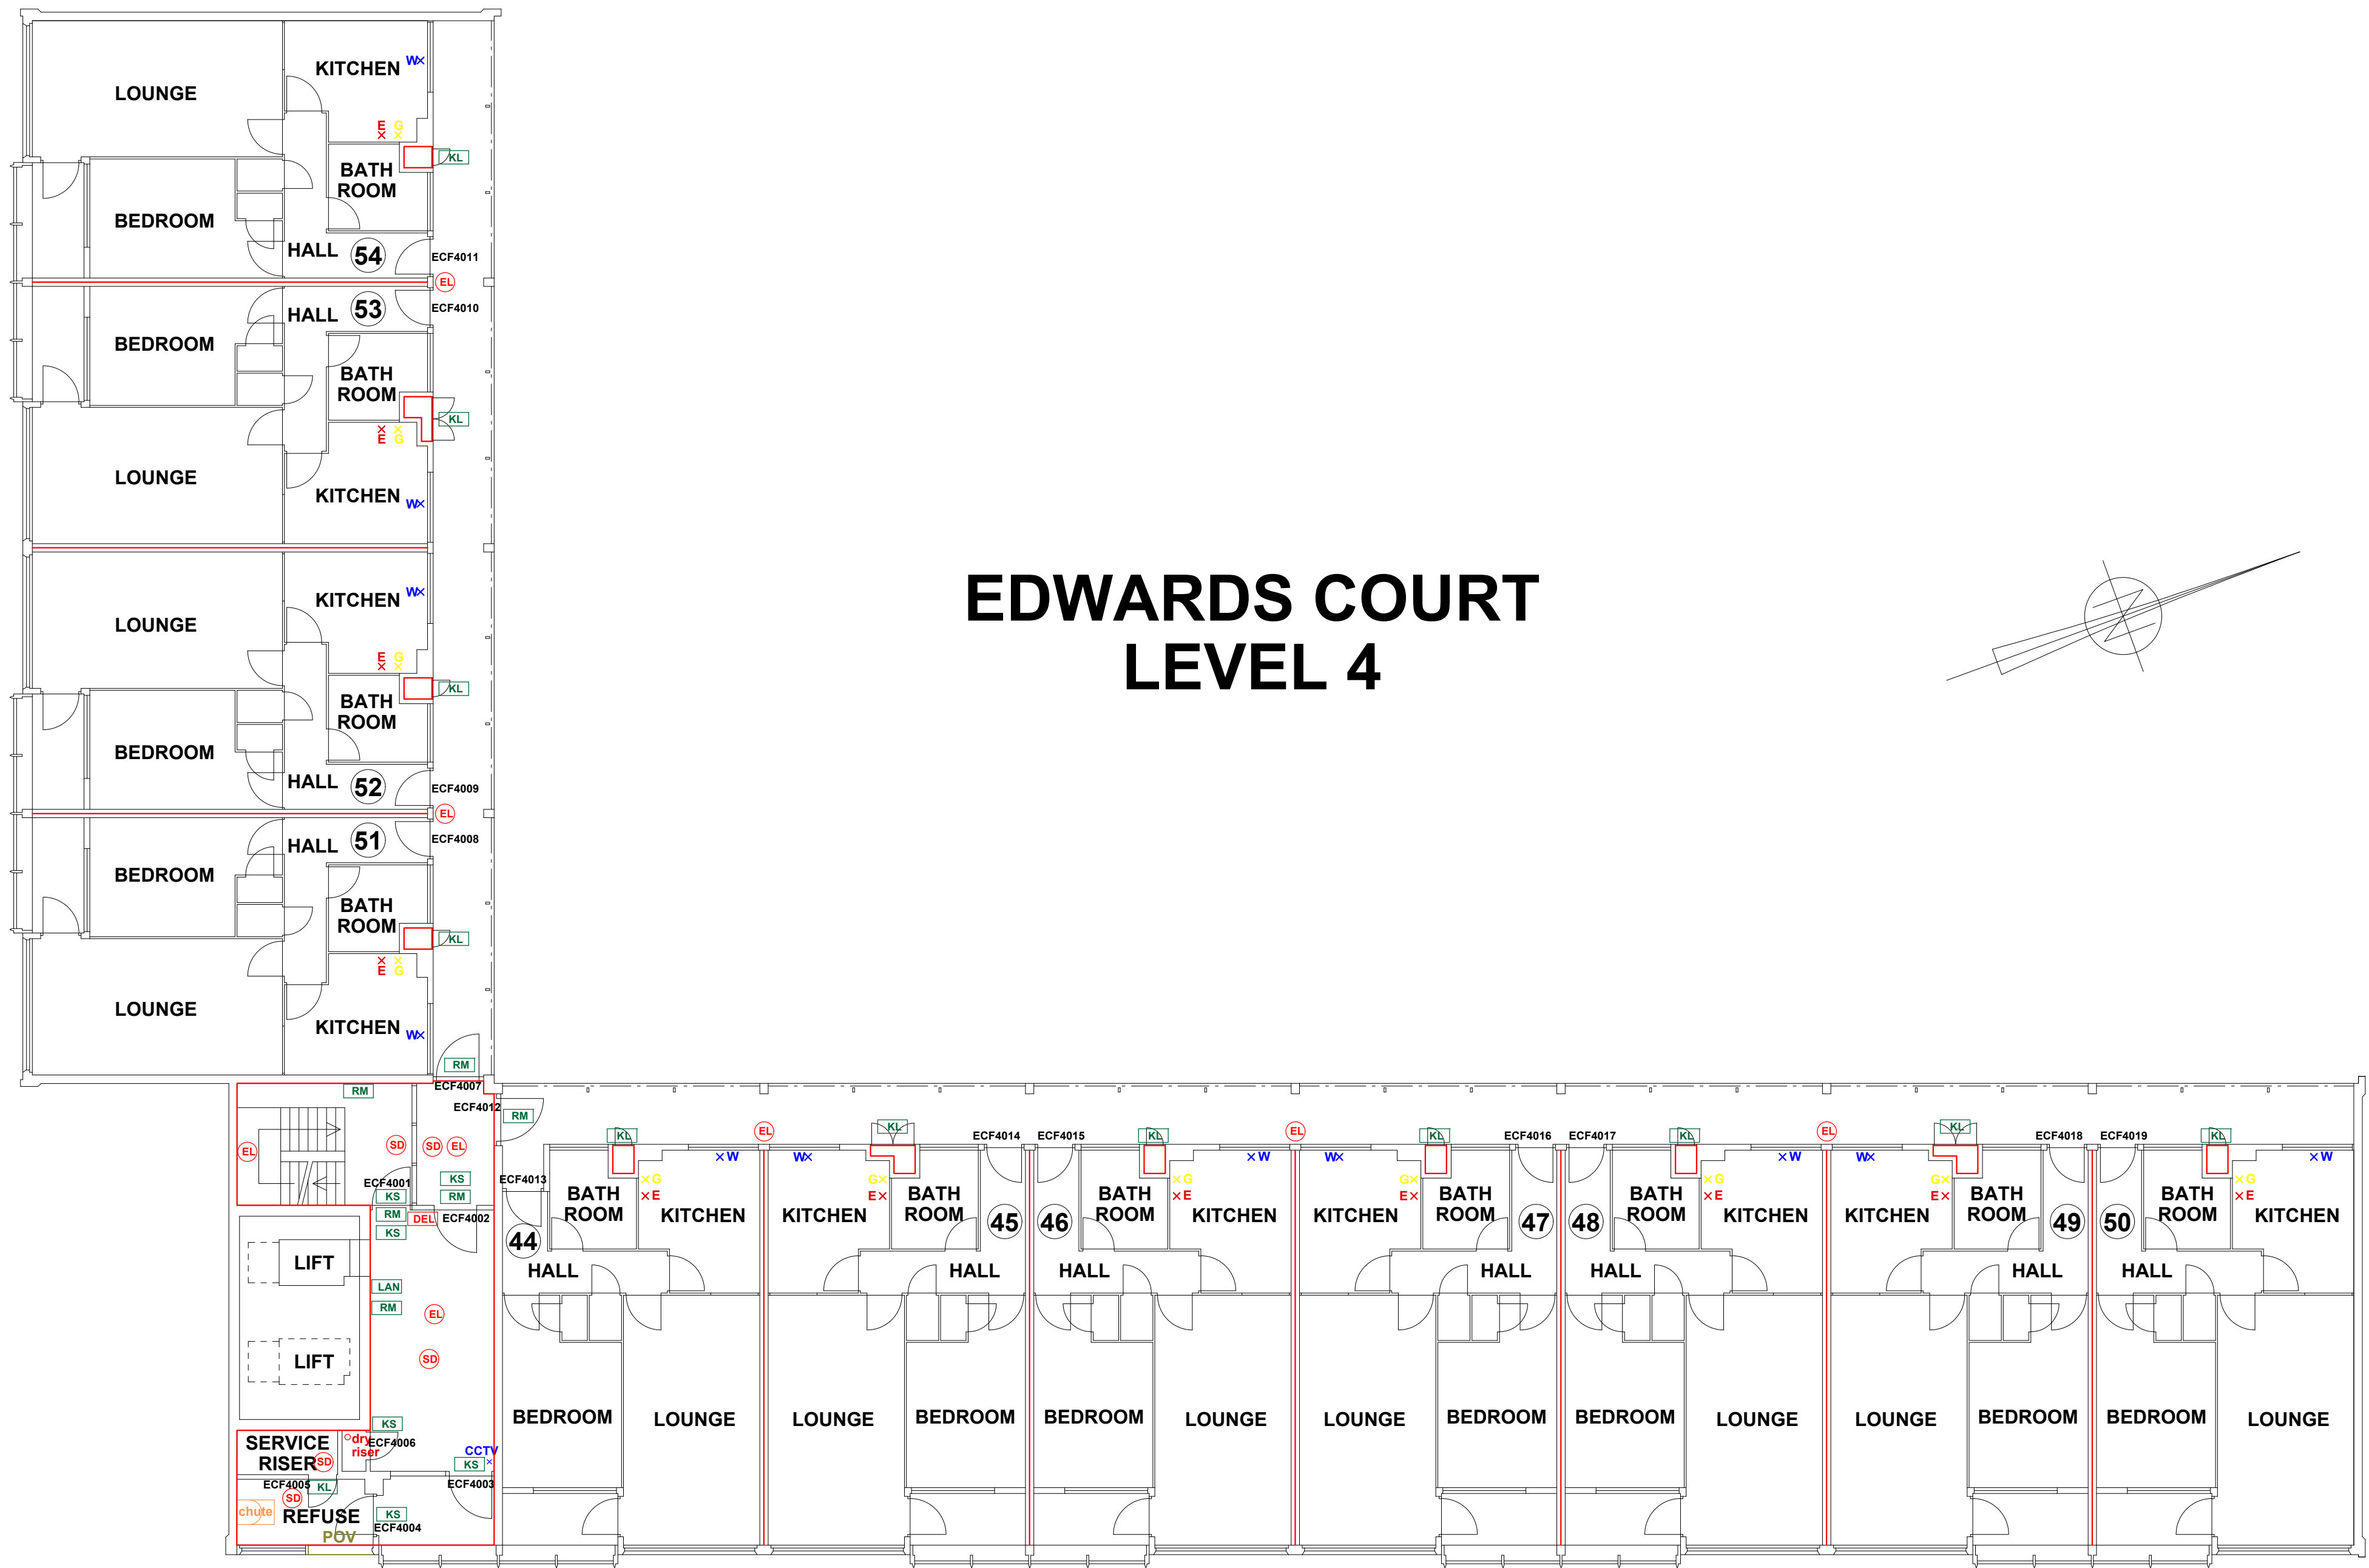

EDWARDS COURT LEVEL 4

FIRE PRECAUTIONS LEGEND

- ⊙ Break glass type fire alarm call point
- ⊙ HB Heat sensitive detectors
- ⊙ SD Smoke sensitive detectors
- ⊙ EL Emergency light point.
- ⊙ FS Firemans Switch
- ⊙ DKA Emergency Drop Key Access
- FAP Fire alarm indicator / repeat panel
- GD1 Door/Access fitted with Gerda D1 Key lock
- FB1 Door/Access fitted with FB1 Key lock
- FB2 Door/Access fitted with FB2 Key lock
- FB4 Door/Access fitted with FB4 Key lock
- FB11P Door/Access fitted with FB11 Padlock
- FB14P Door/Access fitted with FB14 Padlock
- DRO Dry Riser Outlet
- DEL Digital electronic lock door entry/exit system
- PIB Premises Information Box
- POV Permanently Open Vent
- AOV Automatic Opening Vent
- OV Openable Vent
- Fire alarm sounder ('X' indicates integral flashing - Xenon light)

EXTINGUISH

- BLNRT 1.1m x 1.1m fire blanket - base of container to be 1500mm above floor level
- AF 6 litres AFFF aqueous foam extinguisher to BS:6575
- 4 9 litre wet chemical type extinguisher
- DP 4.5 4.5 litre dry powder type extinguisher
- 2 2 kg carbon dioxide type extinguisher
- CO 4.5 4.5 kg carbon dioxide type extinguisher
- W 9 9 kg water type extinguisher
- W 6 6 litre water type extinguisher

FIRE EXIT SIGNAGE

- E 'E' Signs to be externally illuminated by adjacent emergency light point
- FE 'FE' denotes as previous but illuminated as part of sign
- RM 'RM' denotes non illuminated sign

FIRE DOOR SIGNS AND FIRE ACTION NOTICES

- FAN Fire Action Notice
- EFFP Emergency Floor Plan
- KS "FIRE DOOR KEEP SHUT" sign
- KL "FIRE DOOR KEEP LOCKED" sign
- KC "AUTOMATIC FIRE DOOR KEEP CLEAR" or "FIRE EXIT KEEP CLEAR" sign
- LAN "CAUTION, IN THE EVENT OF FIRE DO NOT USE THIS LIFT"
- DB DISTRIBUTION BOARD



SCALE (METRES)

REV DATE AMENDMENTS



WEB: WWW.FIRNTEC.COM
EMAIL: CONTACTUS@FIRNTEC.COM
ADDRESS: 1ST FLOOR, ENDEAVOUR HOUSE,
PARKWAY CT, PLYMOUTH PL6 8LR
TEL: 01752 877 147

PROJECT: EDWARDS COURT

ADDRESS: WYTHENSHAW
MANCHESTER
M22 5SF


DWG NO.: EC_220020L05

DWG TITLE: LEVEL 4

DWG DATE: NOVEMBER 2022

DWG SIZE: SCALE 1:100 @ A1

DRAWN: NR CHECKED: BR

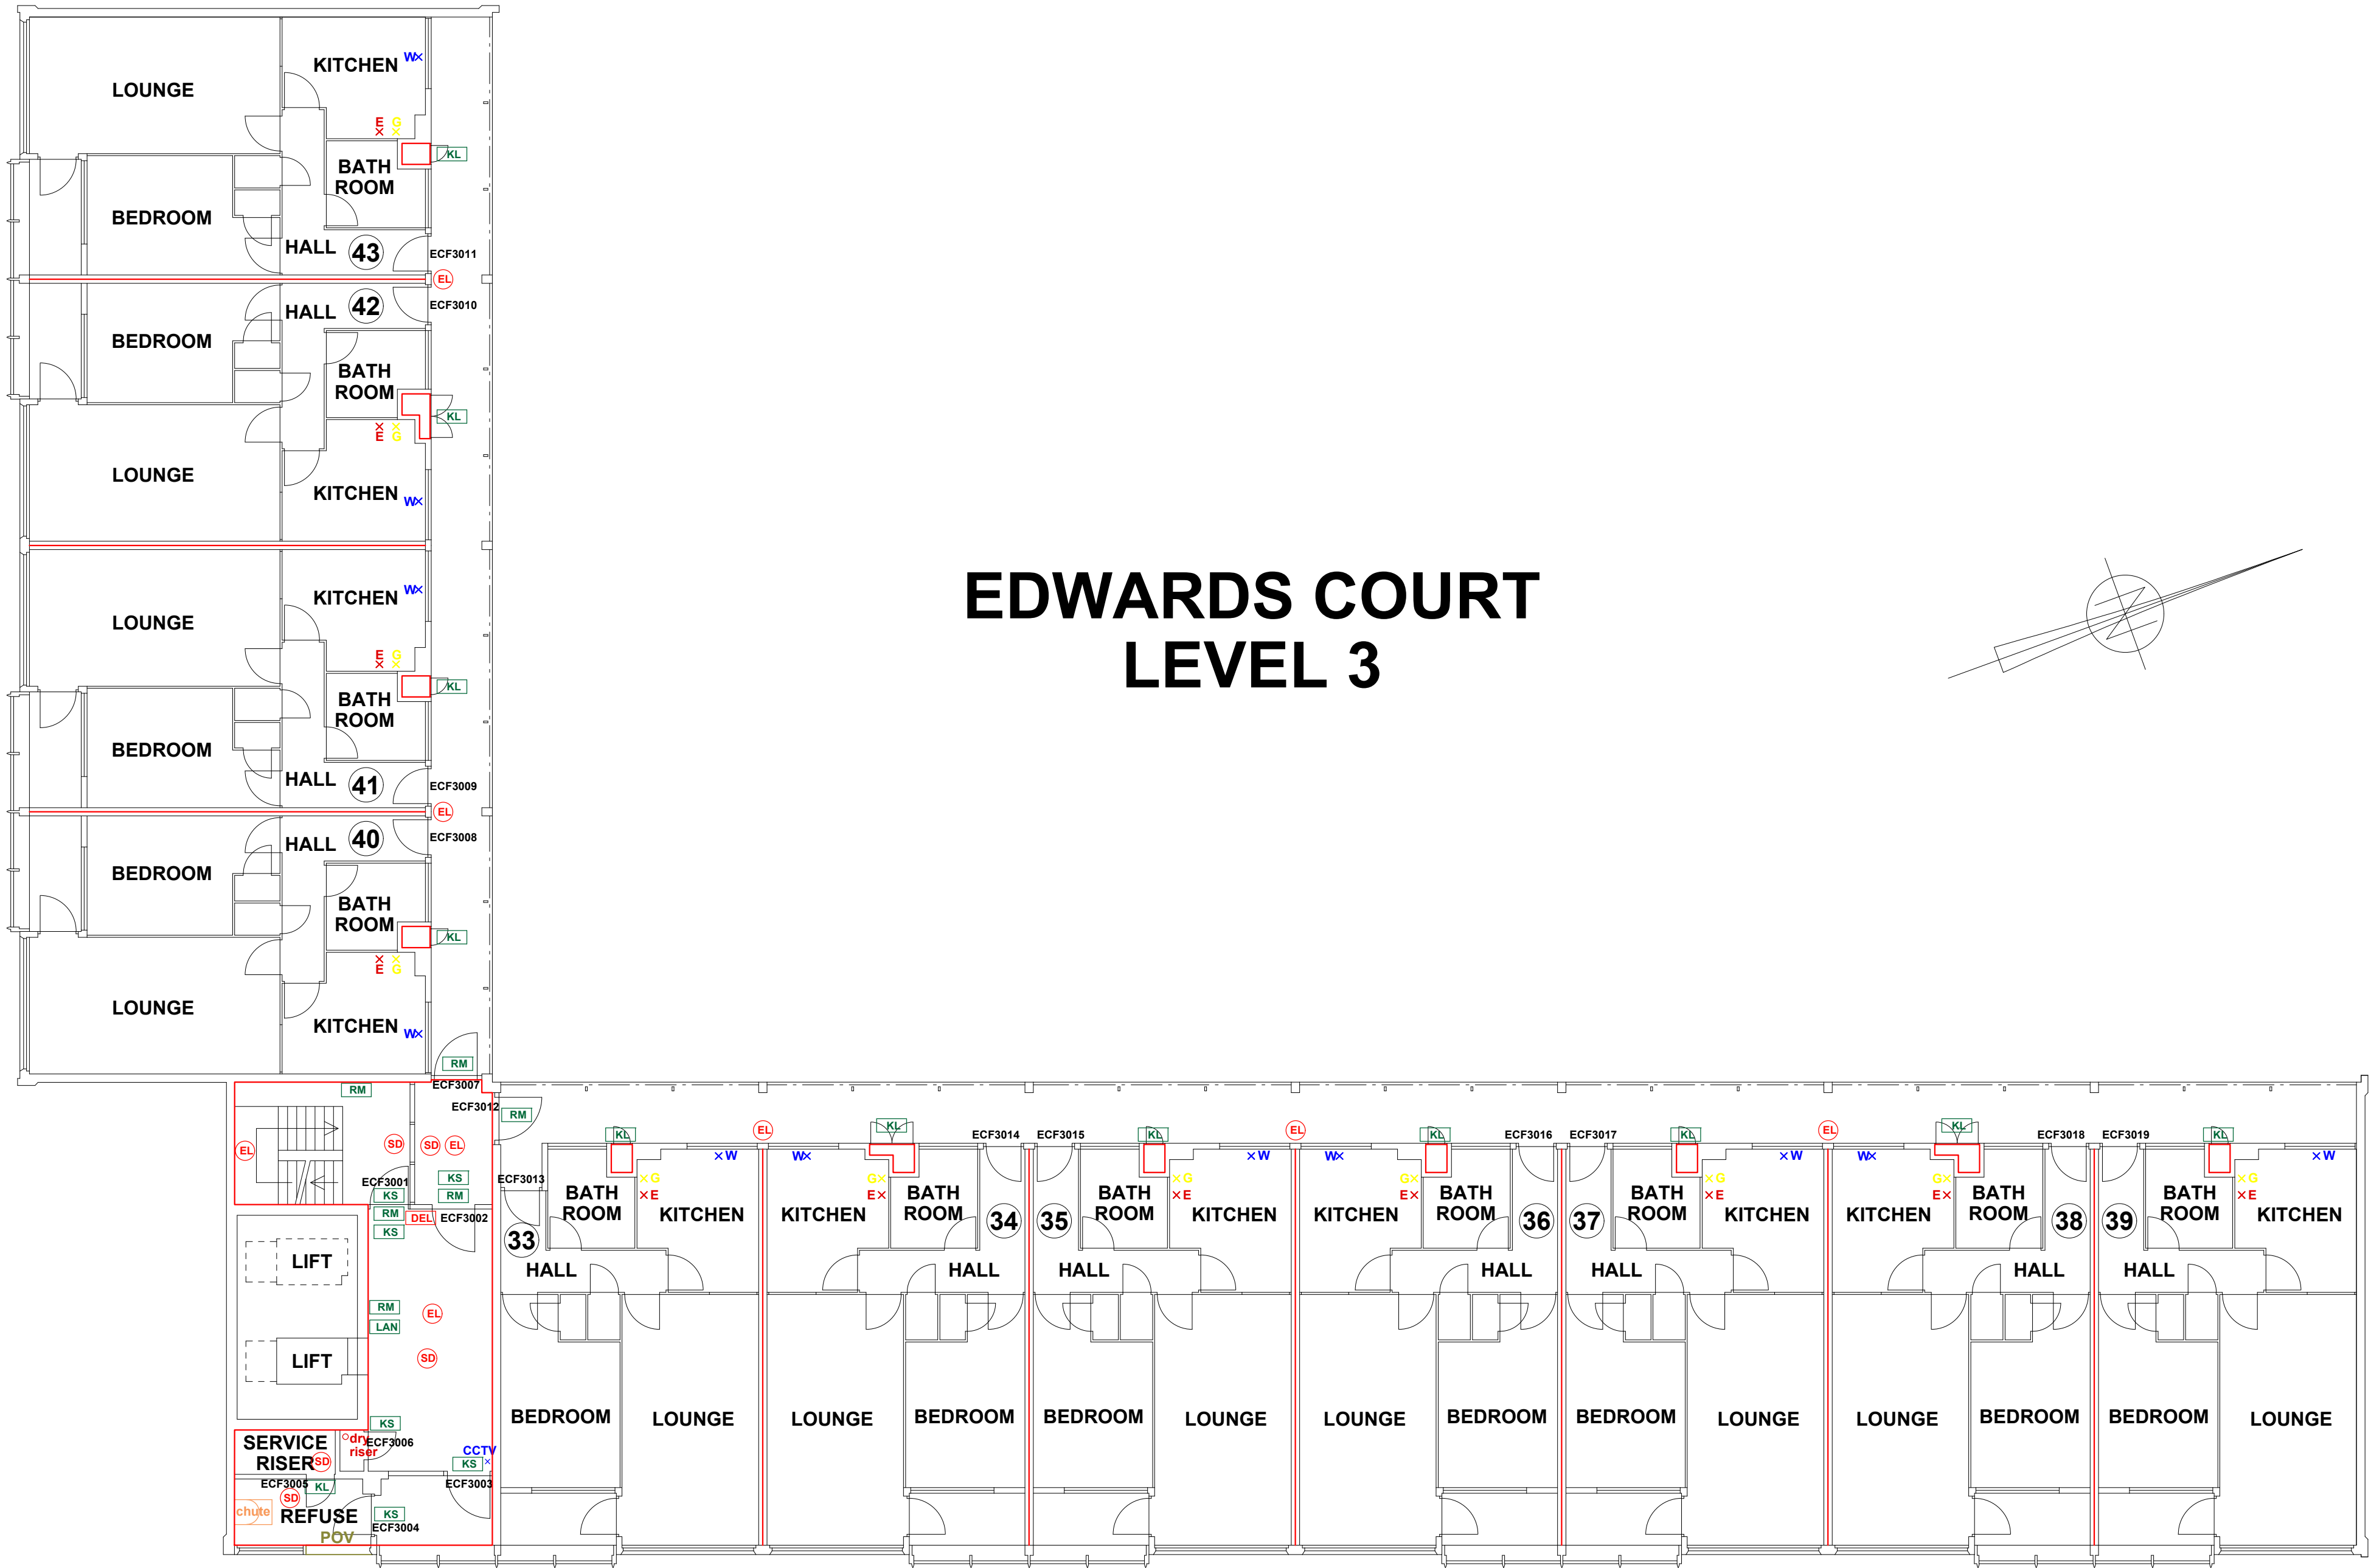

FIRE PRECAUTIONS LEGEND

- ⊙ Break glass type fire alarm call point
- ⊙ HB Heat sensitive detectors
- ⊙ SD Smoke sensitive detectors
- ⊙ EL Emergency light point.
- ⊙ FS Firemans Switch
- ⊙ DKA Emergency Drop Key Access
- FAP Fire alarm indicator / repeat panel
- GD1 Door/Access fitted with Gerda D1 Key lock
- FB1 Door/Access fitted with FB1 Key lock
- FB2 Door/Access fitted with FB2 Key lock
- FB4 Door/Access fitted with FB4 Key lock
- FB11P Door/Access fitted with FB11 Padlock
- FB14P Door/Access fitted with FB14 Padlock
- DRO Dry Riser Outlet
- DEL Digital electronic lock door entry/exit system
- PIB Premises Information Box
- POV Permanently Open Vent
- AOV Automatic Opening Vent
- OV Openable Vent
- Fire alarm sounder ('X' indicates integral flashing - Xenon light)
- CCTV CCTV Security Camera
- FB Fire Brigade Key Access
- EXTINGUISH
 - BLNRT 1.1m x 1.1m fire blanket - base of container to be 1500mm above floor level
 - AF 6 litres AFFF aqueous foam extinguisher to BS:6575
 - 4 9 litre wet chemical type extinguisher
 - DP 4.5 4.5 litre dry powder type extinguisher
 - CD 2 2 kg carbon dioxide type extinguisher
 - CD 4.5 4.5 kg carbon dioxide type extinguisher
 - W 9 9 kg water type extinguisher
 - W 6 6 litre water type extinguisher
- FIRE EXIT SIGNAGE
 - E 'E' Signs to be externally illuminated by adjacent emergency light point
 - FE 'FE' denotes as previous but illuminated as part of sign
 - RM 'RM' denotes non illuminated sign
- FIRE DOOR SIGNS AND FIRE ACTION NOTICES
 - FAN Fire Action Notice
 - EFPP Emergency Floor Plan
 - KS "FIRE DOOR KEEP SHUT" sign
 - KL "FIRE DOOR KEEP LOCKED" sign
 - KC "AUTOMATIC FIRE DOOR KEEP CLEAR" or "FIRE EXIT KEEP CLEAR" sign
 - LAN "CAUTION, IN THE EVENT OF FIRE DO NOT USE THIS LIFT"
 - DB DISTRIBUTION BOARD




SCALE (METRES)

REV DATE AMENDMENTS



WEB: WWW.FIRNTEC.COM
EMAIL: CONTACTUS@FIRNTEC.COM
ADDRESS: 1ST FLOOR, ENDEAVOUR HOUSE,
PARKWAY CT, PLYMOUTH PL6 8LR
TEL: 01752 877 147

PROJECT: EDWARDS COURT
ADDRESS: EDWARDS COURT
WYTHENSHAW
MANCHESTER
M22 3SF
DWG NO.: EC_220020L04
DWG TITLE: LEVEL 3
DWG DATE: NOVEMBER 2022
DWG SIZE: SCALE 1:100 @ A1
DRAWN: NR CHECKED: BR

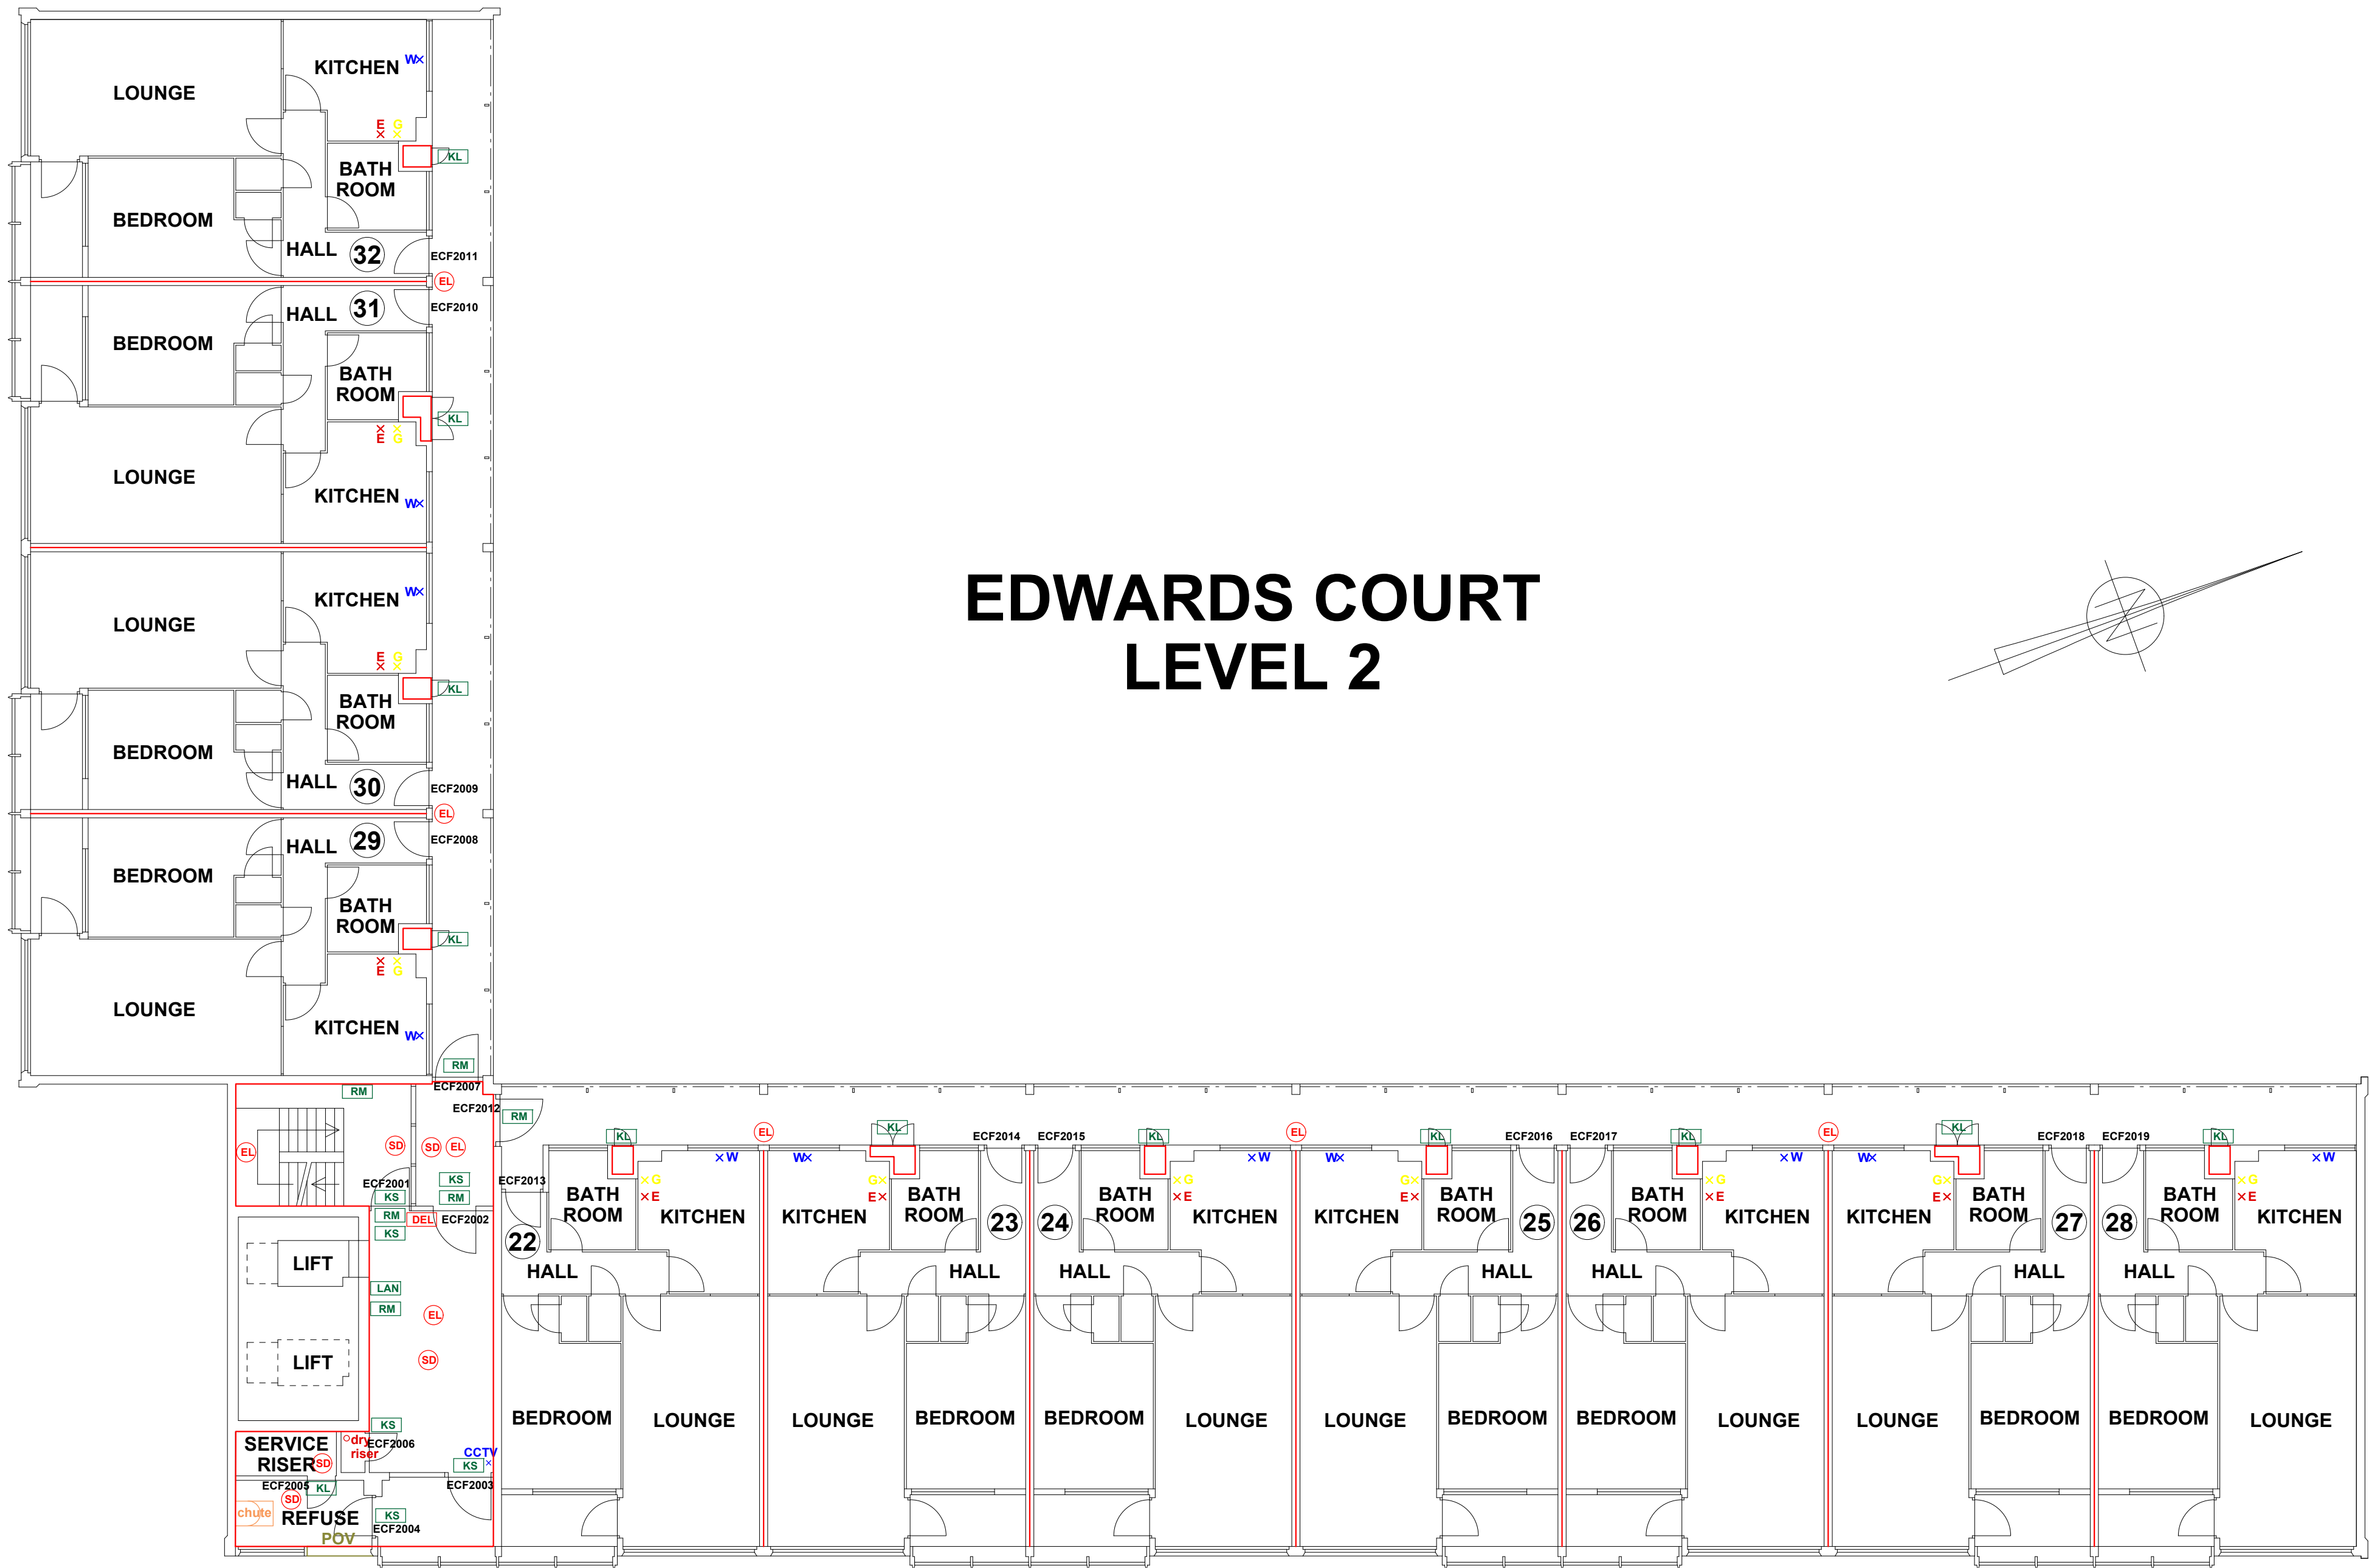

FIRE PRECAUTIONS LEGEND

- ⊙ Break glass type fire alarm call point
- ⊙ HB Heat sensitive detectors
- ⊙ SD Smoke sensitive detectors
- ⊙ EL Emergency light point.
- ⊙ FS Firemans Switch
- ⊙ DKA Emergency Drop Key Access
- FAP Fire alarm indicator / repeat panel
- GD1 Door/Access fitted with Gerda D1 Key lock
- FB1 Door/Access fitted with FB1 Key lock
- FB2 Door/Access fitted with FB2 Key lock
- FB4 Door/Access fitted with FB4 Key lock
- FB11P Door/Access fitted with FB11 Padlock
- FB14P Door/Access fitted with FB14 Padlock
- DRO Dry Riser Outlet
- DEL Digital electronic lock door entry/exit system
- PIB Premises Information Box
- POV Permanently Open Vent
- AOV Automatic Opening Vent
- OV Openable Vent
- Fire alarm sounder ('X' indicates integral flashing - Xenon light)
- CCTV CCTV Security Camera
- FB Fire Brigade Key Access
- EXTINGUISH
- BLNRT 1.1m x 1.1m fire blanket - base of container to be 1500mm above floor level
- AF 6 litres AFFF aqueous foam extinguisher to BS:6575
- C 9 litre wet chemical type extinguisher
- DP 4.5 4.5 litre dry powder type extinguisher
- CD 2 kg carbon dioxide type extinguisher
- CD 4.5 4.5 kg carbon dioxide type extinguisher
- W 9 kg water type extinguisher
- W 6 6 litre water type extinguisher
- FIRE EXIT SIGNAGE
- E 'E' Signs to be externally illuminated by adjacent emergency light point
- FE 'FE' denotes as previous but illuminated as part of sign
- RM 'RM' denotes non illuminated sign
- FIRE DOOR SIGNS AND FIRE ACTION NOTICES
- FAN Fire Action Notice
- EFP Emergency Floor Plan
- KS "FIRE DOOR KEEP SHUT" sign
- KL "FIRE DOOR KEEP LOCKED" sign
- KC "AUTOMATIC FIRE DOOR KEEP CLEAR" or "FIRE EXIT KEEP CLEAR" sign
- LAN "CAUTION, IN THE EVENT OF FIRE DO NOT USE THIS LIFT"
- DB DISTRIBUTION BOARD


0 5 10
SCALE (METRES)

REV DATE AMENDMENTS



WEB: WWW.FIRNTEC.COM
EMAIL: CONTACTUS@FIRNTEC.COM
ADDRESS: 1ST FLOOR, ENDEAVOUR HOUSE,
PARKWAY CT, PLYMOUTH PL6 8LR
TEL: 01752 877 147

PROJECT: EDWARDS COURT
ADDRESS: EDWARDS COURT
WYTHENSHAW
MANCHESTER
M22 3SF
DWG NO.: EC_220020L03
DWG TITLE: LEVEL 2
DWG DATE: NOVEMBER 2022
DWG SIZE: SCALE 1:100 @ A1
DRAWN: NR CHECKED: BR

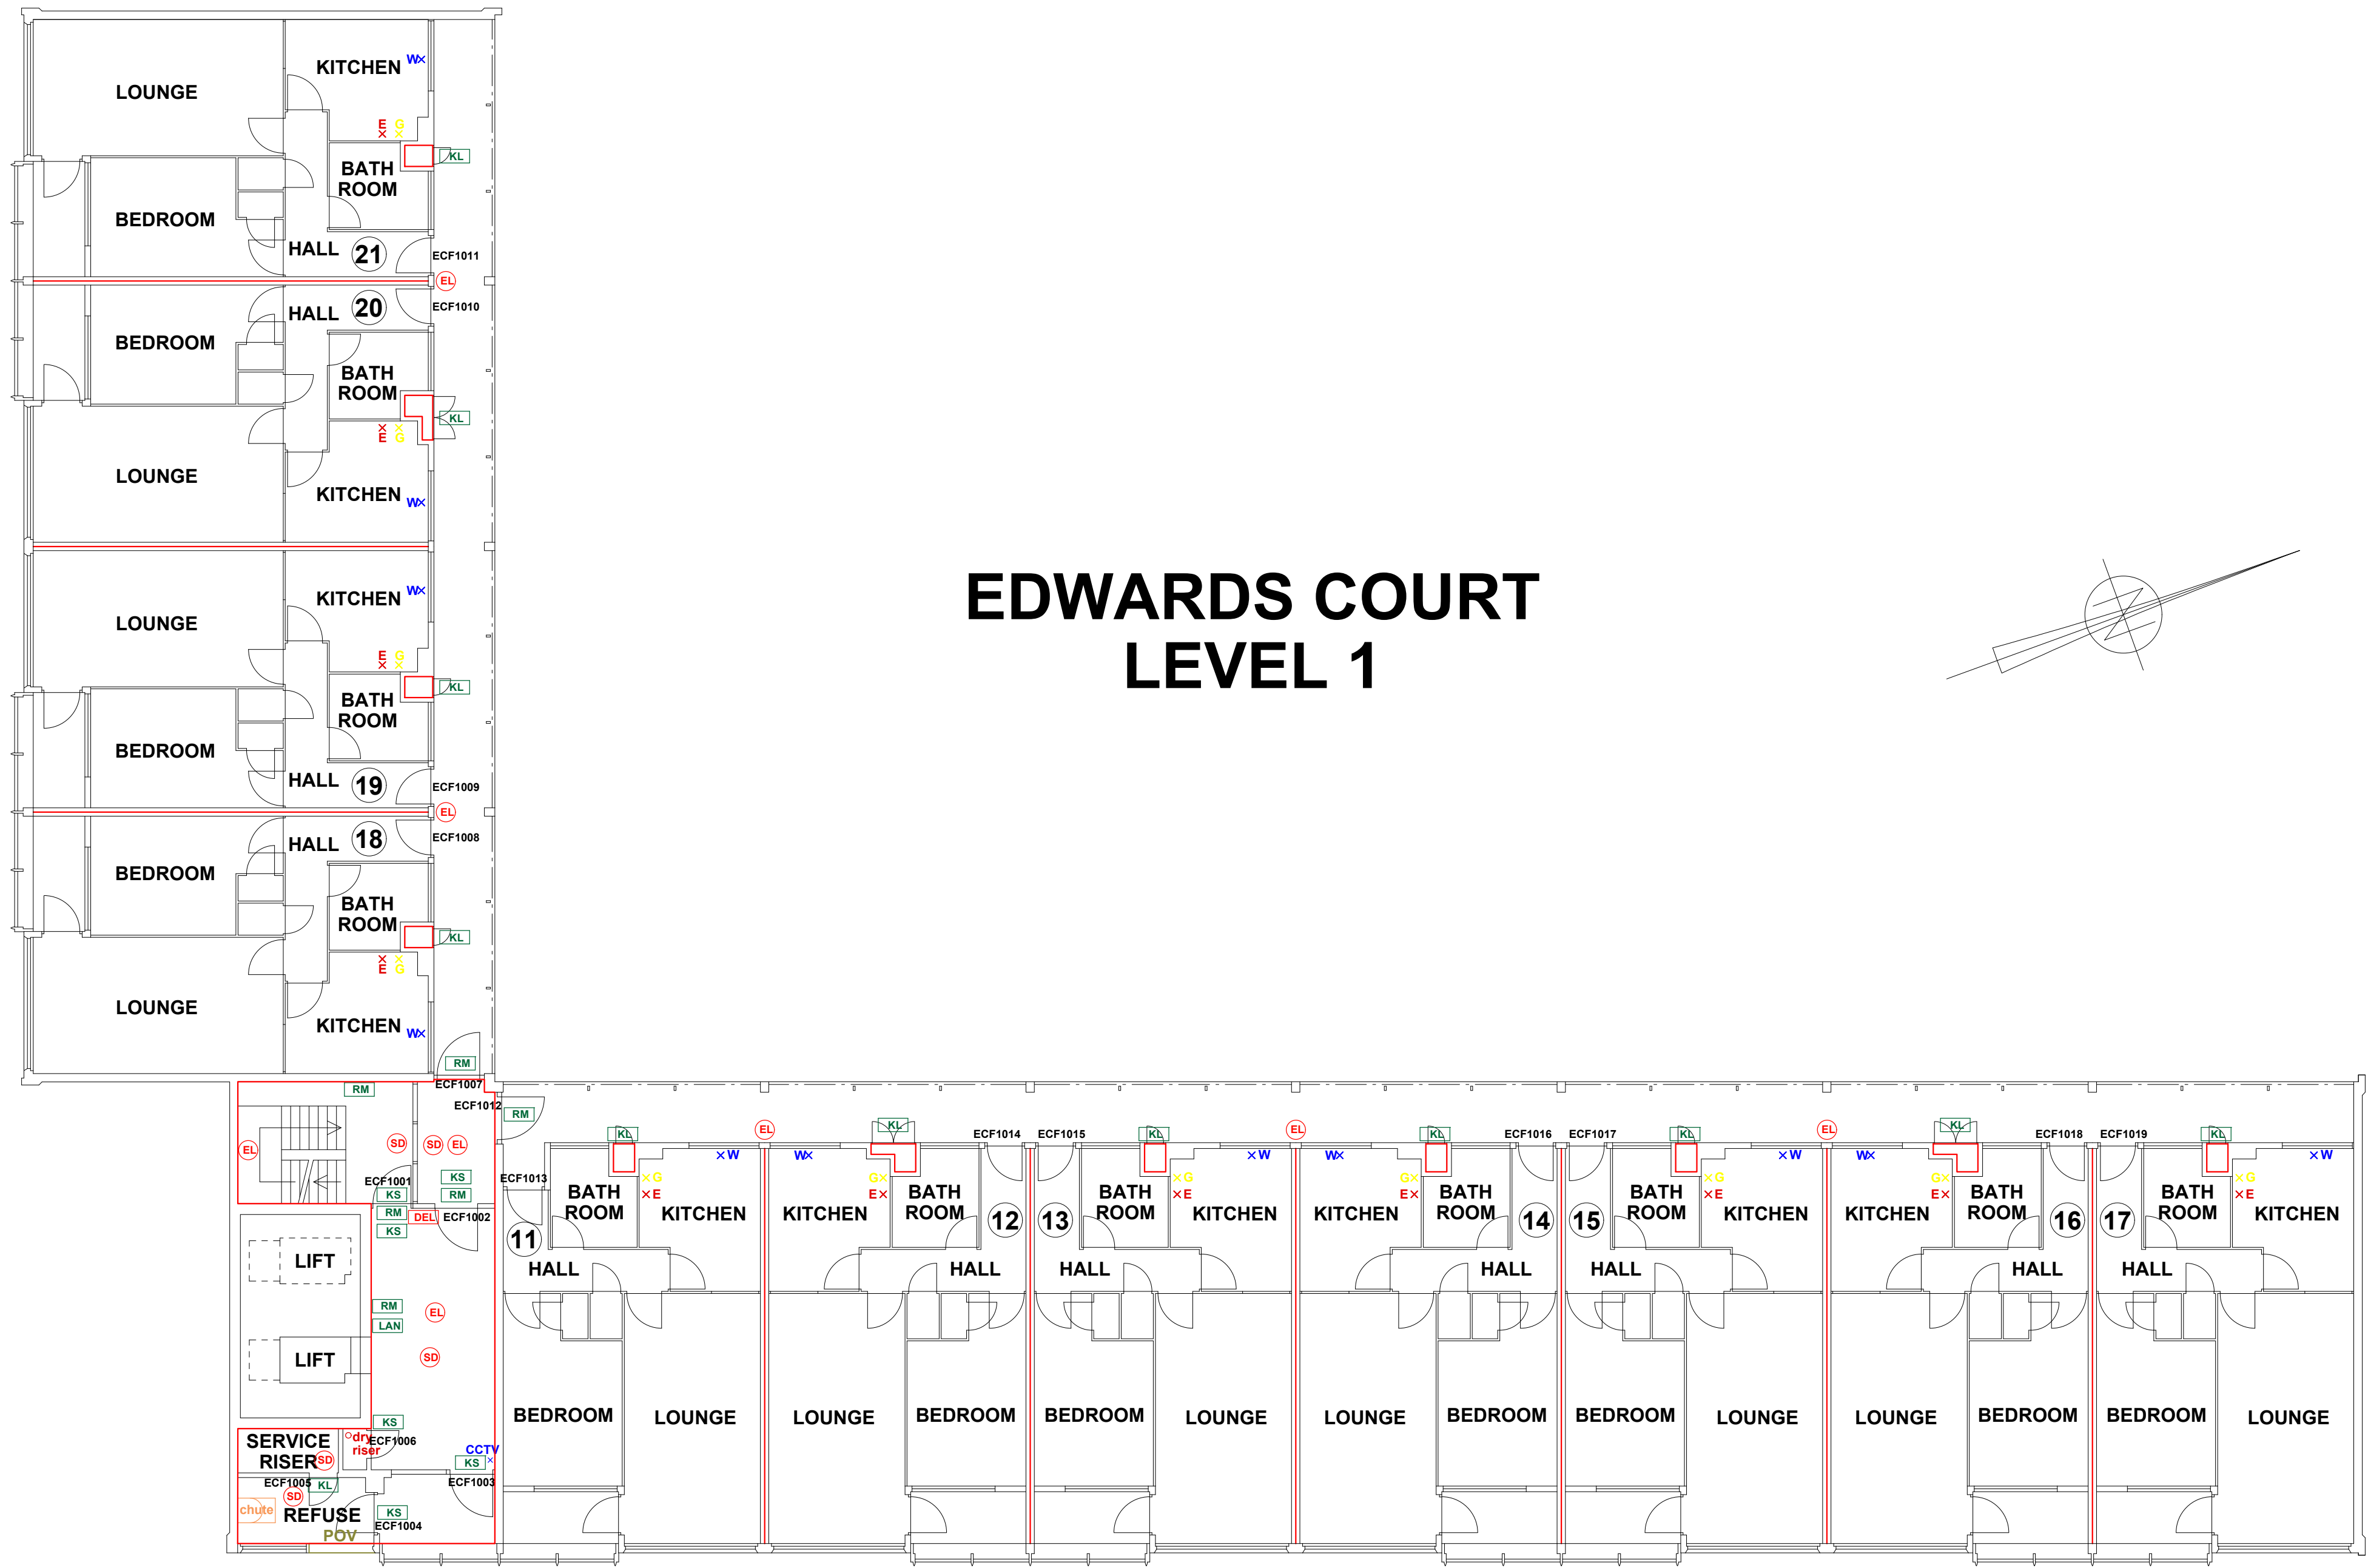

FIRE PRECAUTIONS LEGEND

- ⊙ Break glass type fire alarm call point
- ⊙ HB Heat sensitive detectors
- ⊙ SD Smoke sensitive detectors
- ⊙ EL Emergency light point.
- ⊙ FS Firemans Switch
- ⊙ DKA Emergency Drop Key Access
- FAP Fire alarm indicator / repeat panel
- GD1 Door/Access fitted with Gerda D1 Key lock
- FB1 Door/Access fitted with FB1 Key lock
- FB2 Door/Access fitted with FB2 Key lock
- FB4 Door/Access fitted with FB4 Key lock
- FB11P Door/Access fitted with FB11 Padlock
- FB14P Door/Access fitted with FB14 Padlock
- DRO Dry Riser Outlet
- DEL Digital electronic lock door entry/exit system
- PIB Premises Information Box
- POV Permanently Open Vent
- AOV Automatic Opening Vent
- OV Openable Vent
- Fire alarm sounder ('X' indicates integral flashing - Xenon light)
- CCTV CCTV Security Camera
- FB Fire Brigade Key Access
- EXTINGUISH
- BLNRT 1.1m x 1.1m fire blanket - base of container to be 1500mm above floor level
- AF 6 litres AFFF aqueous foam extinguisher to BS:6575
- C 9 litre wet chemical type extinguisher
- DP 4.5 4.5 litre dry powder type extinguisher
- CD 2 kg carbon dioxide type extinguisher
- CD 4.5 4.5 kg carbon dioxide type extinguisher
- W 9 kg water type extinguisher
- W 6 6 litre water type extinguisher
- FIRE EXIT SIGNAGE
- E 'E' Signs to be externally illuminated by adjacent emergency light point
- FE 'FE' denotes as previous but illuminated as part of sign
- RM 'RM' denotes non illuminated sign
- FIRE DOOR SIGNS AND FIRE ACTION NOTICES
- FAN Fire Action Notice
- EFP Emergency Floor Plan
- KS "FIRE DOOR KEEP SHUT" sign
- KL "FIRE DOOR KEEP LOCKED" sign
- KC "AUTOMATIC FIRE DOOR KEEP CLEAR" or "FIRE EXIT KEEP CLEAR" sign
- LAN "CAUTION, IN THE EVENT OF FIRE DO NOT USE THIS LIFT"
- DB DISTRIBUTION BOARD

0 5 10
SCALE (METRES)

REV DATE AMENDMENTS



WEB: WWW.FIRNTEC.COM
EMAIL: CONTACTUS@FIRNTEC.COM
ADDRESS: 1ST FLOOR, ENDEAVOUR HOUSE,
PARKWAY CT, PLYMOUTH PL6 8LR
TEL: 01752 877 147

PROJECT: EDWARDS COURT

ADDRESS: WYTHENSHAW

MANCHESTER

M22 SSE

DWG NO.: EC_220020L02

DWG TITLE: LEVEL 1

DWG DATE: NOVEMBER 2022

DWG SIZE: SCALE 1:100 @ A1

DRAWN: NR CHECKED: BR